

7223 COASTAL BLVD., BROOKSVILLE FL 34613

**PETCO**  
645 RICHLAND HILLS DRIVE  
SAN ANTONIO, TX 78245


**PETCO ANIMAL SUPPLIES**  
**BROOKSVILLE**  
 7223 COASTAL BLVD., BROOKSVILLE FL 34613



A diagram of a circle with a vertical red line segment inside. The line segment is labeled 'N' above it.

## SHEET INDEX

Project Owner:

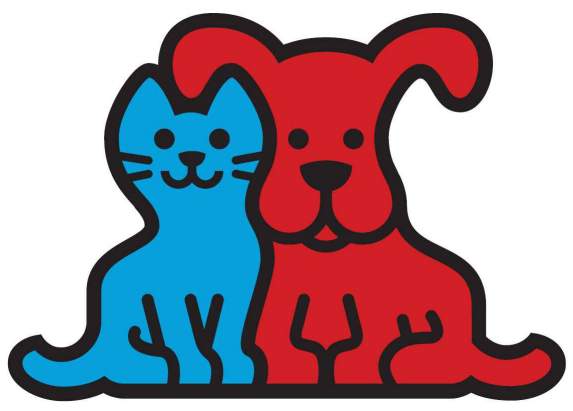

Consultant:

Plans, maps, specifications, studies, and reports not containing a red ink seal imprint accompanied by an original signature by the licensed professional shall not be considered an original copy. All information should be disregarded unless verified by the professional whose signature appears below.

Copyright Protected 2017

Project Address:

PETCO  
7223 COASTAL BLVD  
BROOKSVILLE FL 34613

Stamp

Keyplan:

- CANOPY ABOVE
- COLUMN (SIZES SHOWN ON PLAN)
- STOREFRONT SYSTEM
- MAIN ENTRY
- LOW WALL (HEIGHTS SHOWN ON PLAN)
- CONCRETE PEIR
- WOOD TRELLIS FENCE
- WATER HEATER
- ALUMINUN ROLL-UP DOOR
- BUILT IN-MILLWORK (DIMENSIONS SHOWN ON PLAN)
- FISH TANK
- FIRE SPRINKLER RISER (NO ACCESS)
- ROOF LADDER
- PLUMBING WALL
- RADIATOR HEATER
- CASH WRAP
- STAIRS
- FIRE SPRINKLER VALVE
- FIRE HOSE CABINET
- FIRE DEPARTMENT CONTROL PANEL
- BASEBOARD HEATER
- BOILERS
- MAIN DISTRIBUTION PANEL
- ELECTRICAL GENERATOR
- CONTROL PANEL / LIGHTING CONTROL PANEL
- DRINKING FOUNTAIN
- REPTILE TANK

#### KEYNOTES

- ELEC PANEL - SURFACE
- THERMOSTATIC SENSOR
- THERMOSTAT
- FLOOR DRAIN
- FIRE ALARM PULL STATION
- WALL MOUNTED STROBES
- FIRE EXIT SIGN
- ELEC METER
- JANITOR / SLOP / MOP SINK

#### FLOORING:

- T-LIN LINOLEUM TILE FLOORING
- T-CER CERAMIC TILE FLOORING
- CPT CARPET FLOORING
- VCT VINYL FLOORING
- CONC CONCRETE FLOORING
- EPOXY CONCRETE - APPLIED SEALANT/ WATER PROOFING
- HATCH INDICATES AREA NIC.
- LINE TYPE INDICATES STRUCTURAL GRID LINE

#### LEGEND

- NO ACCESS TO RISER ROOM. ROOM WAS LOOKED AT THE TIME OF SURVEY AND MANAGERS DID NOT HAVE KEYS TO THE ROOM.

Sheet Title:

FLOOR PLAN

DRAWN BY: MV

REVIEWED BY: SE

DWG. DATE: 11.10.2017

PROJECT NUMBER: 22159\_2768

SCALE: AS NOTED


SHEET:


A111

FLOOR PLAN (13,416 NET SQ.FT.)

SCALE  
3/16"=1'-0"

GENERAL NOTES

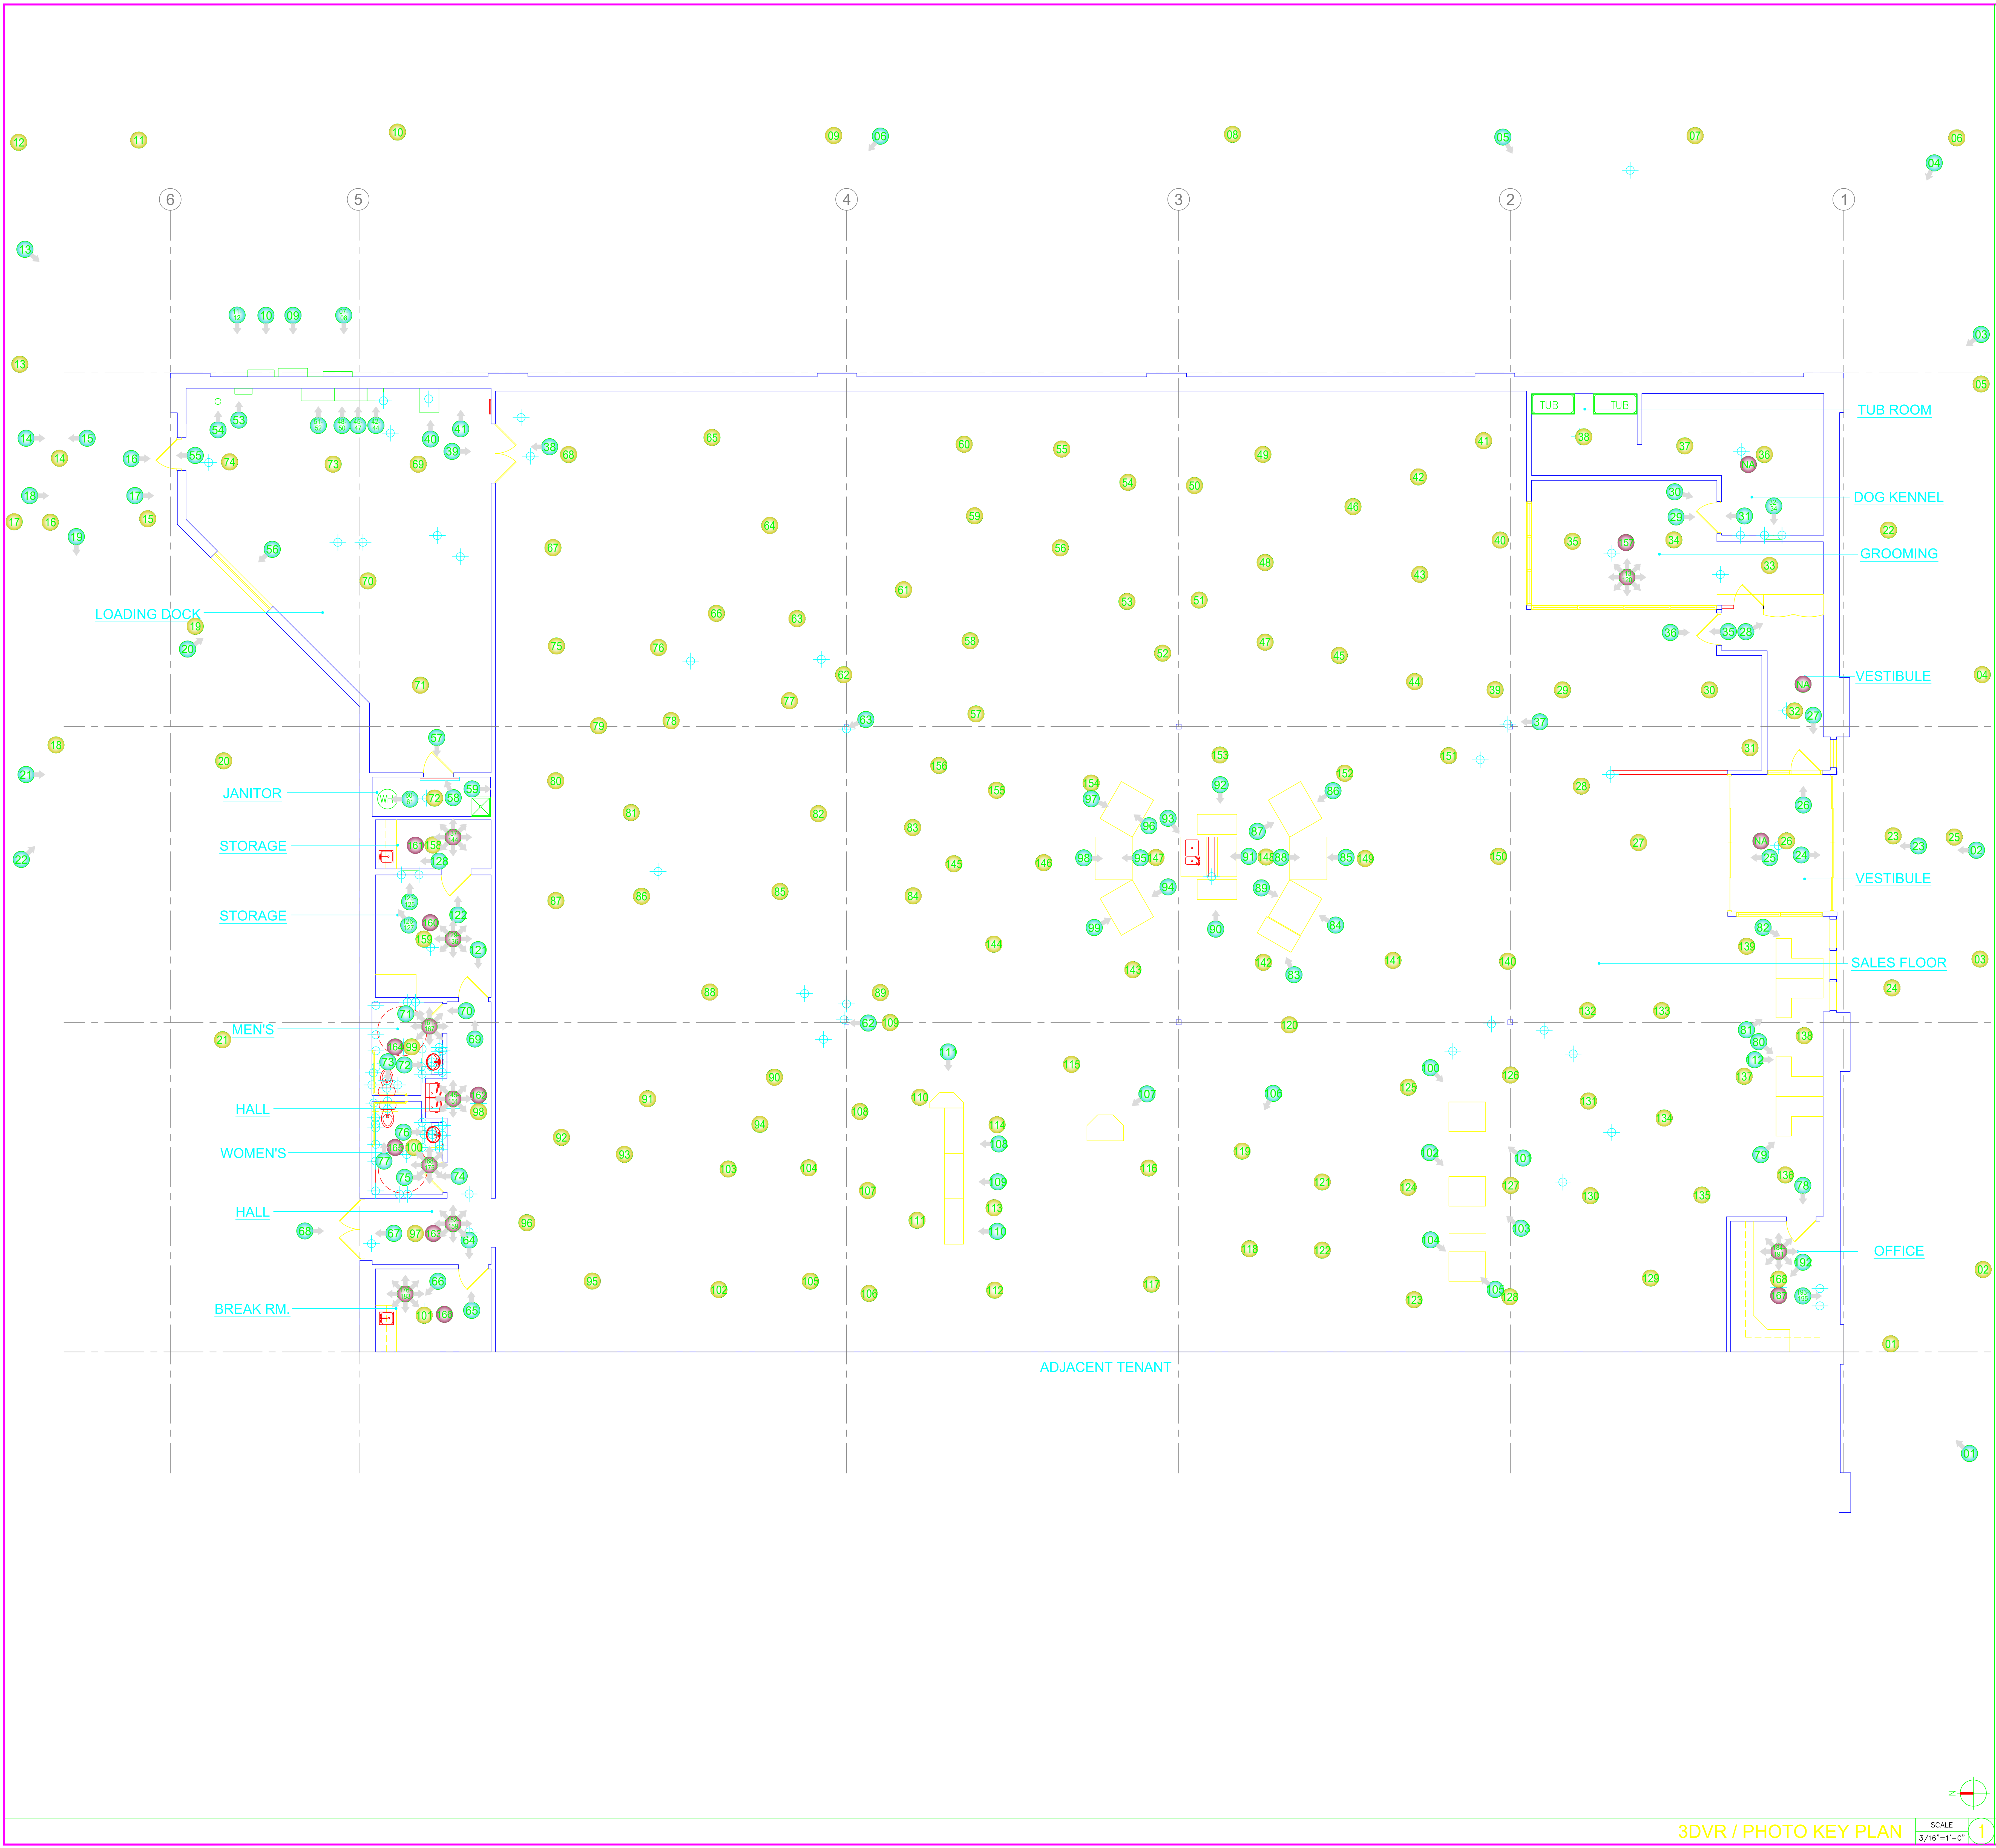[illegible]

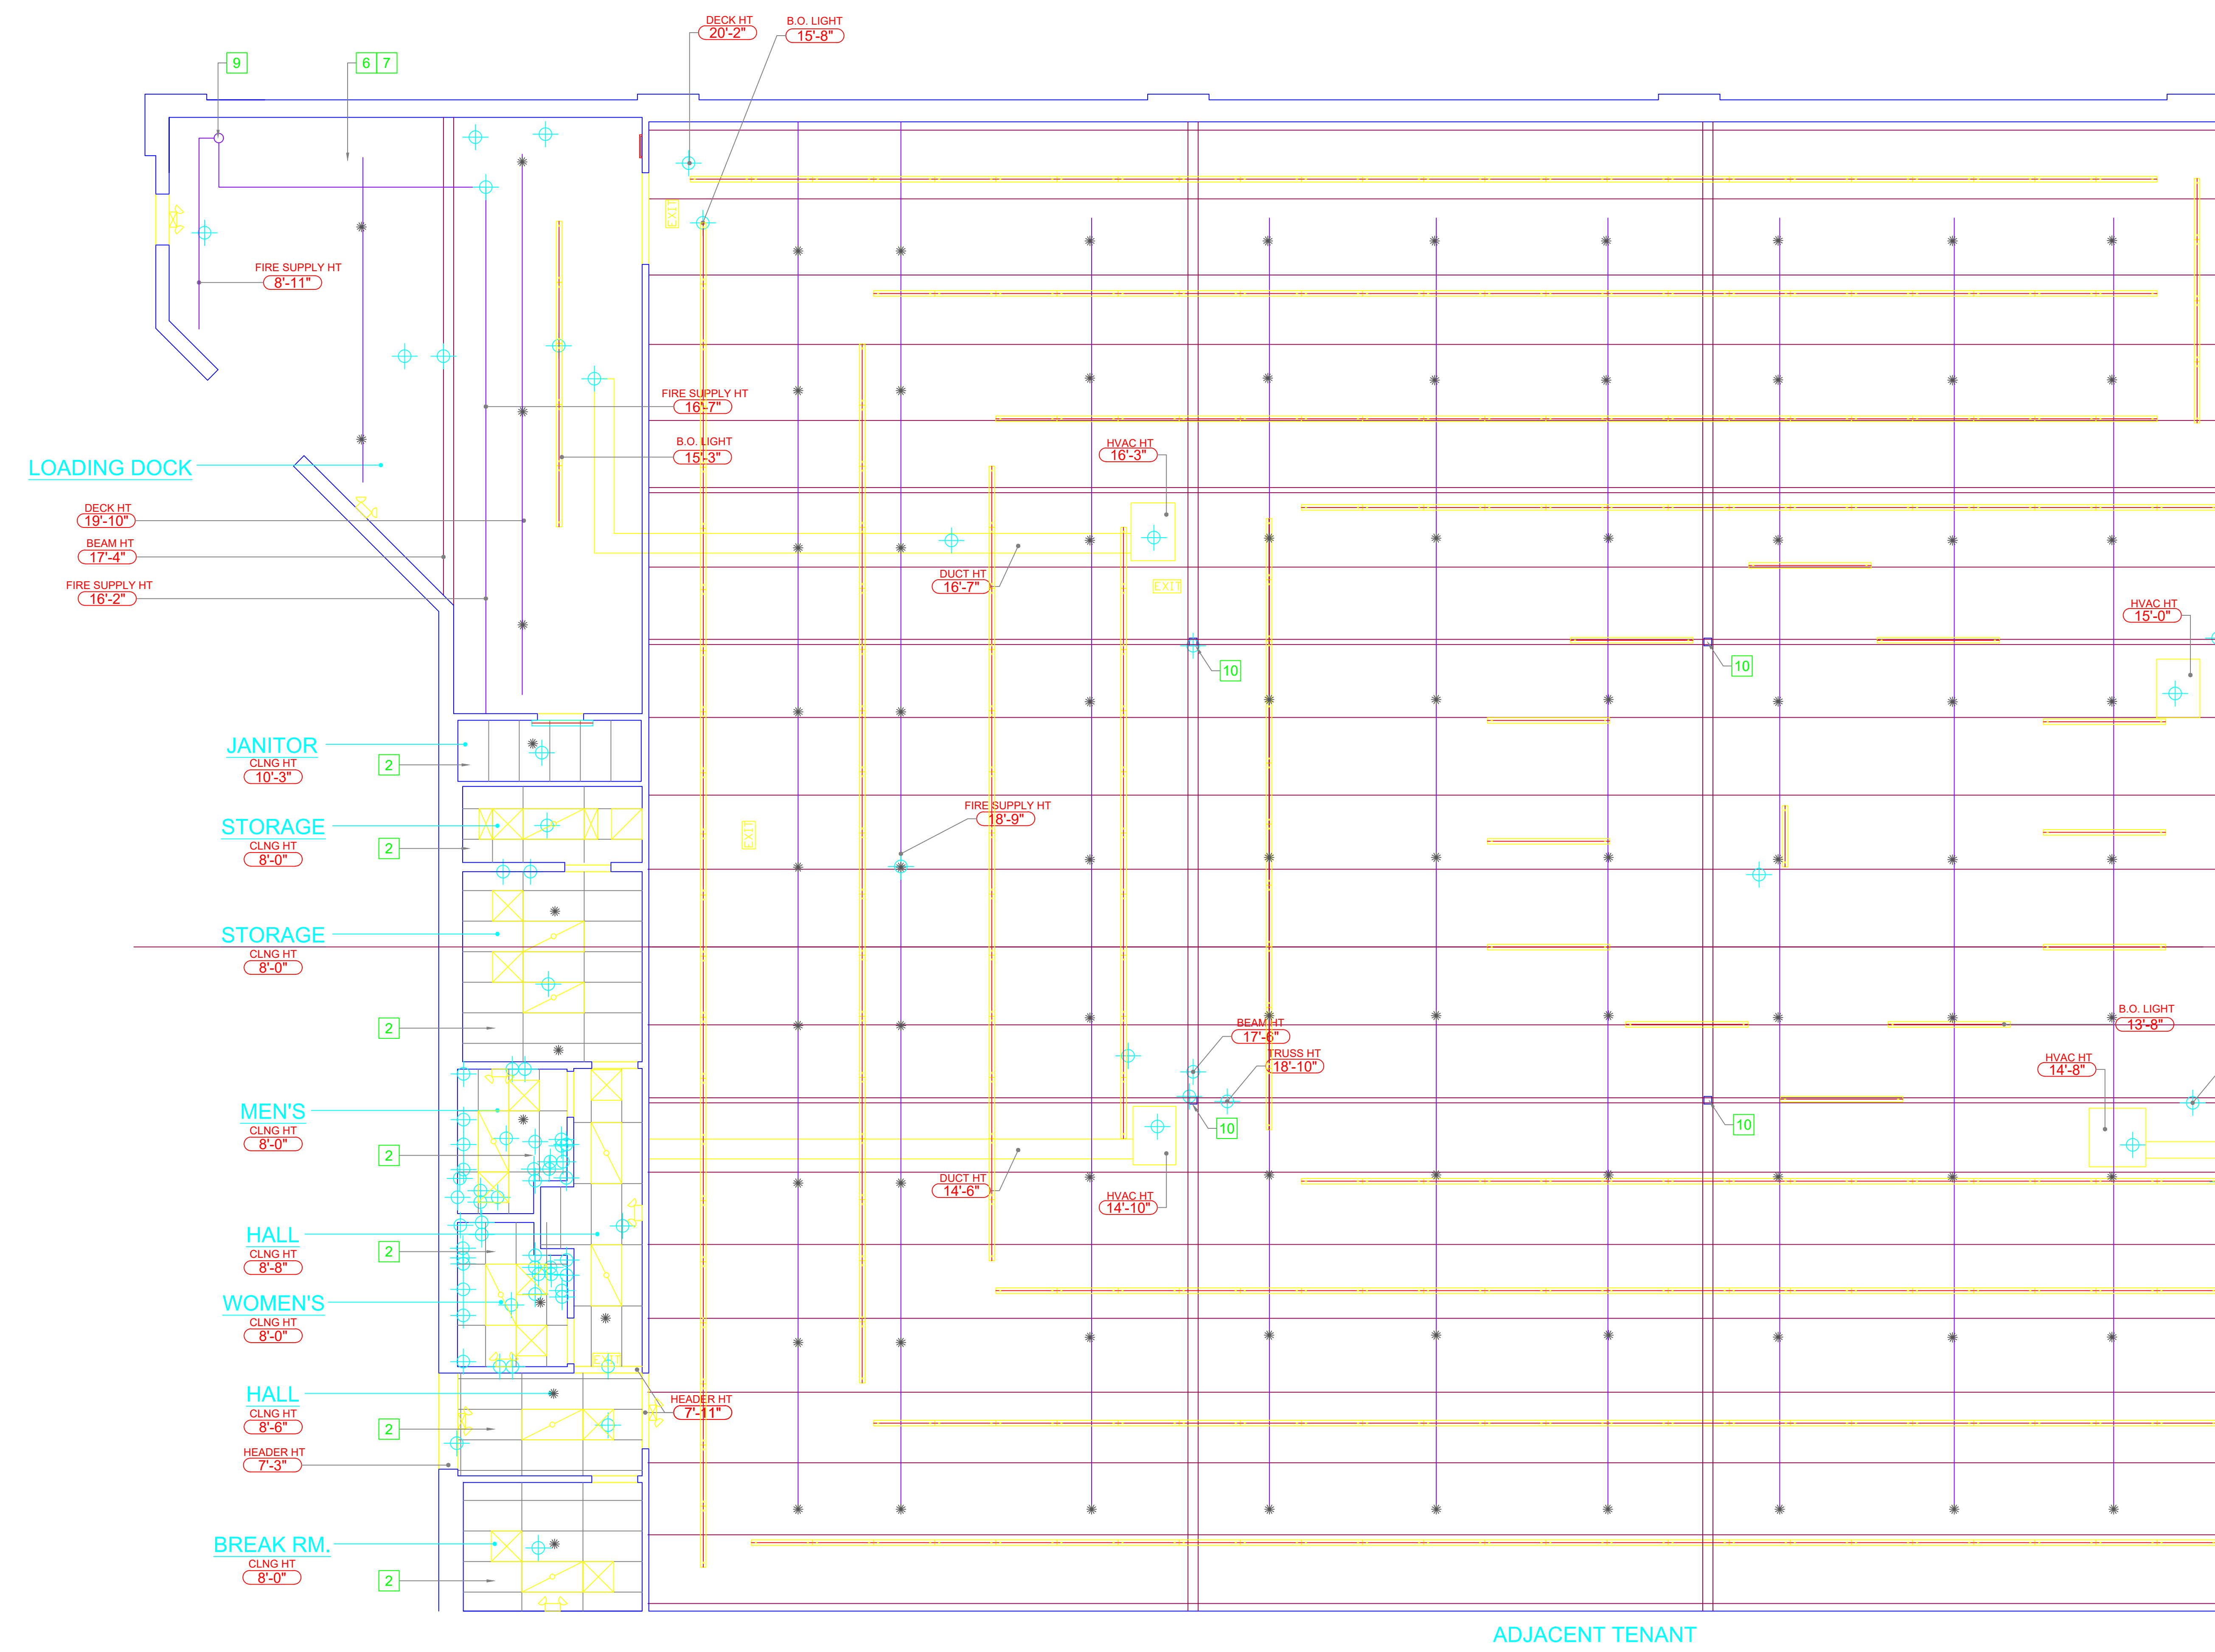



ans, maps, specifications, studies,  
and reports not containing a red ink  
imprint accompanied by an original  
signature by the licensed professional  
may have been fraudulently altered and  
will not be considered an original copy.  
This information should be disregarded  
unless verified by the professional  
whose signature appears below.

**Project Address:**

## Stamp

**Sheet Title:**

DRAWN BY: MV  
 REVIEWED BY: SE  
 DWG. DATE: 11.10.2017  
 PROJECT NUMBER: 22159\_270  
 SCALE: AS NOTED  
 SHEET:

## KEYNOTES

|            |   |
|------------|---|
| SCALE      | 8 |
| 1/4"=1'-0" |   |

|            |   |
|------------|---|
| SCALE      | 4 |
| 1/4"=1'-0" |   |

|            |   |
|------------|---|
| SCALE      | 7 |
| 1/4"=1'-0" |   |

|            |   |
|------------|---|
| SCALE      | 3 |
| 1/4"=1'-0" |   |

|            |   |
|------------|---|
| SCALE      | 6 |
| 1/4"=1'-0" |   |


|            |   |
|------------|---|
| SCALE      | 2 |
| 1/4"=1'-0" |   |

|            |   |
|------------|---|
| SCALE      | 9 |
| 1/4"=1'-0" |   |

|            |   |
|------------|---|
| SCALE      | 5 |
| 1/4"=1'-0" |   |

|            |   |
|------------|---|
| SCALE      | 1 |
| 1/4"=1'-0" |   |



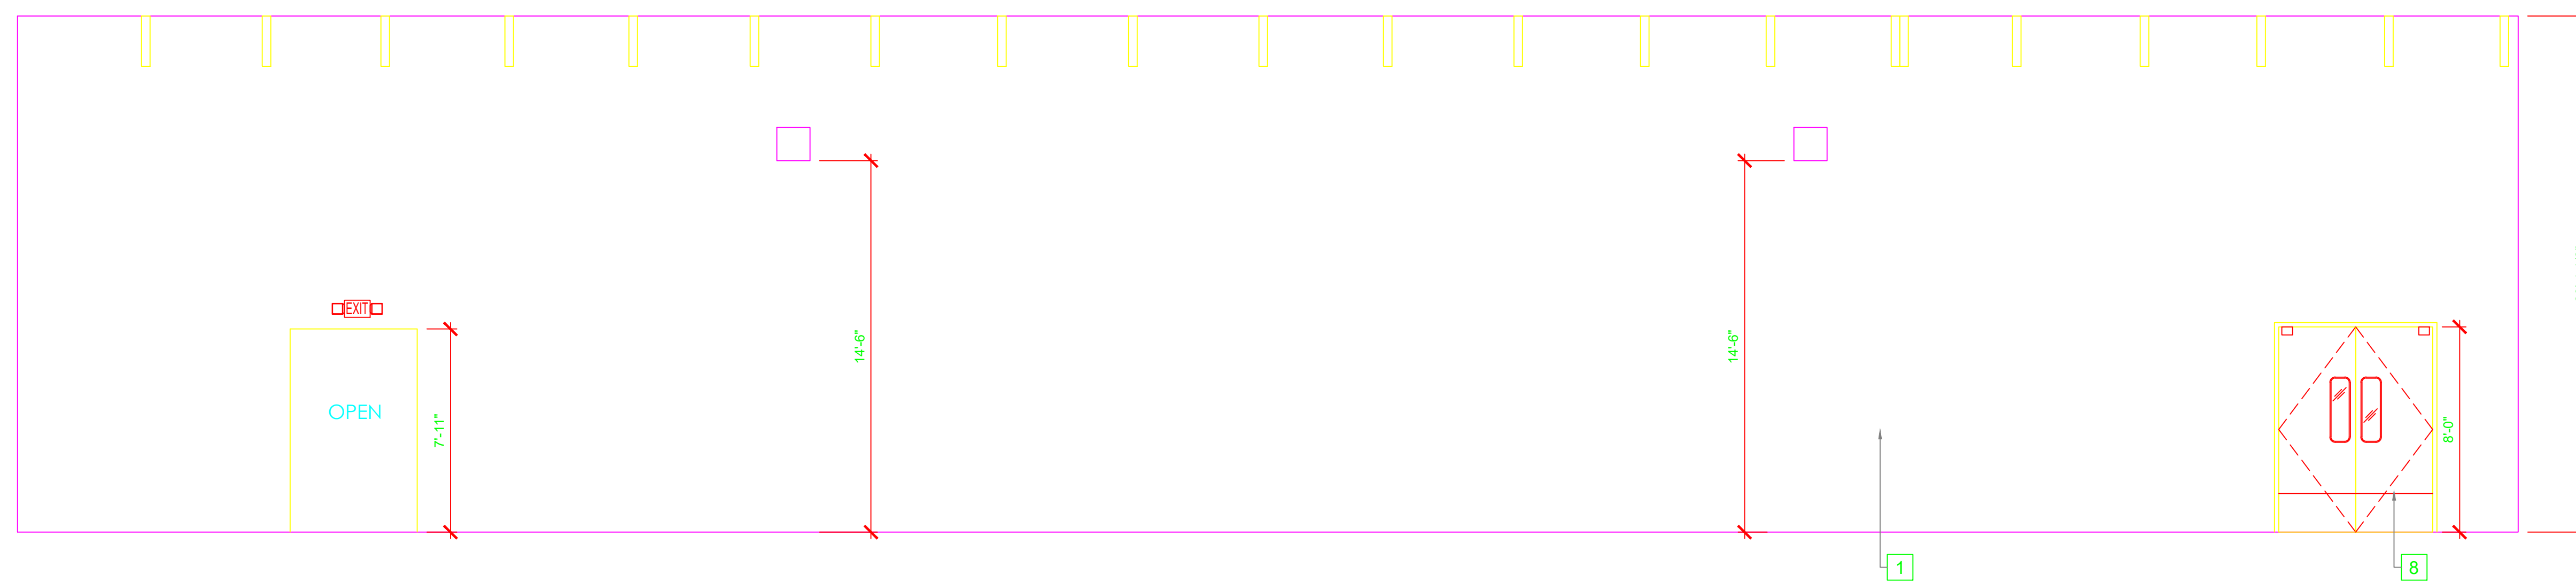


|            |
|------------|
| SCALE      |
| 1/4"=1'-0" |

0"

|            |
|------------|
| SCALE      |
| 1/4"=1'-0" |

0"

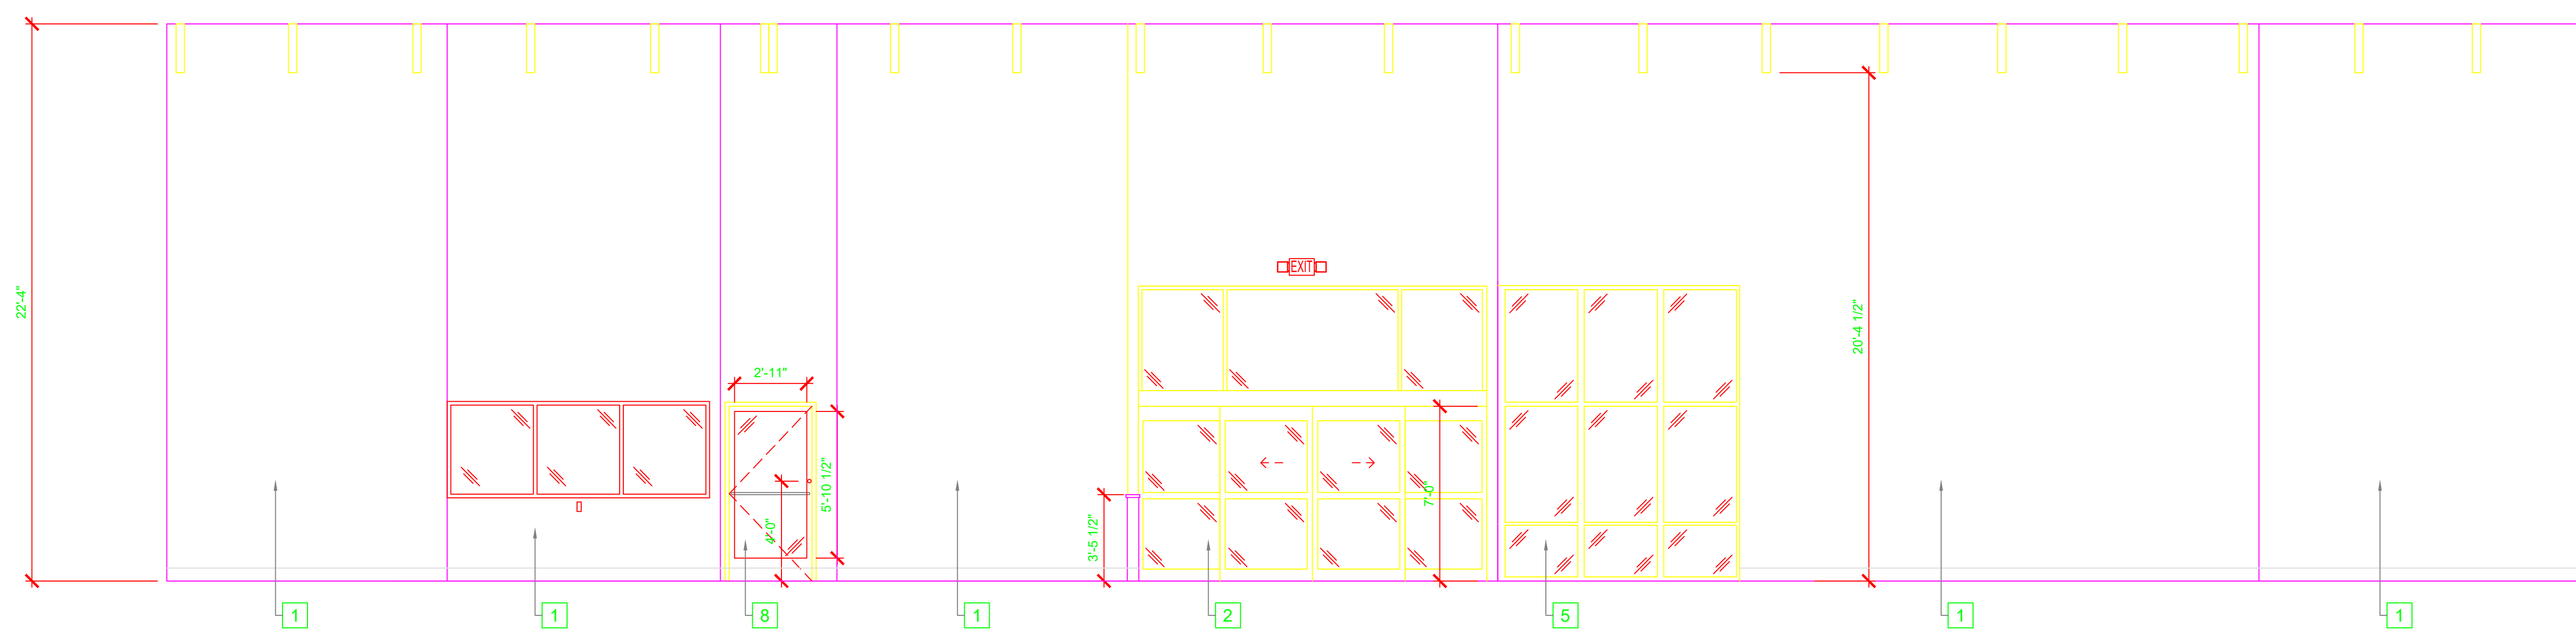


|            |
|------------|
| SCALE      |
| 1/4"=1'-0" |

0"

|            |
|------------|
| SCALE      |
| 1/4"=1'-0" |

2

## KEYNOTES

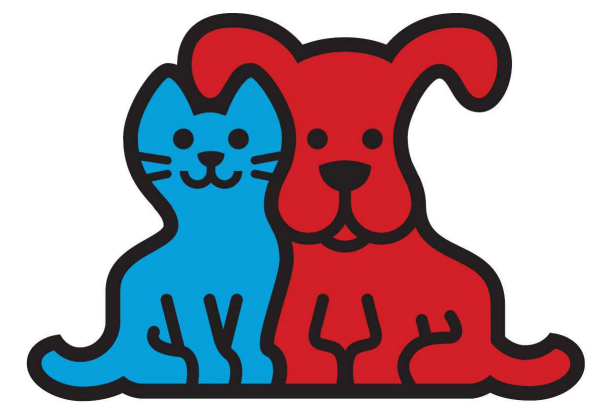**Project Owner:**

**Consultant:**

Copyright Protected 2017

**Project Address:**

**PETCO**  
7223 COASTAL BLVD.,  
BROOKSVILLE FL 34613

## Stamp

**Keyplan:**

[illegible]

**Sheet Title:**

## INTERIOR ELEVATIONS

DRAWN BY: MV

REVIEWED BY: SE

DWG. DATE: 11.10.2017

PROJECT NUMBER: 22159\_276

 
 
SCALE: AS NOTED

SHEET:


A202



|            |   |
|------------|---|
| SCALE      | 3 |
| 1/2"=1'-0" |   |



**Project Owner:**

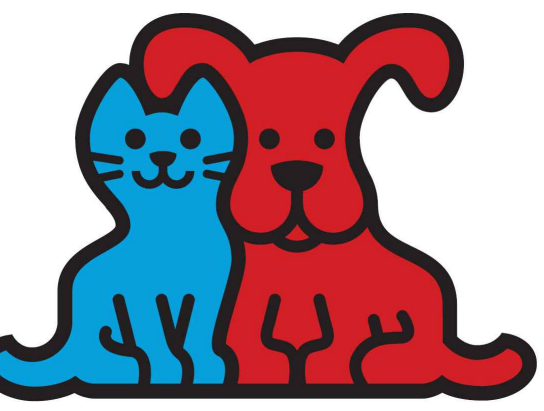

**Consultant:**

ans, maps, specifications, studies, and reports not containing a red ink imprint accompanied by an original signature by the licensed professional may have been fraudulently altered and shall not be considered an original copy. Information should be disregarded unless verified by the professional whose signature appears below.

Copyright Protected 2017

**Project Address:**

**PETCO**  
7223 COASTAL BLVD.,  
BROOKSVILLE FL 34613

## Stamp

### Keyplan:

[illegible]

**Sheet Title:**

## ENLARGED WOMEN'S & MEN'S RESTROOM PLANS AND ELEVATIONS

RAWN BY: MV  
VIEWED BY: SE  
WG. DATE: 11.10.2017  
PROJECT NUMBER: 22159\_2768  
SCALE: AS NOTED  
HEET:

# A400