



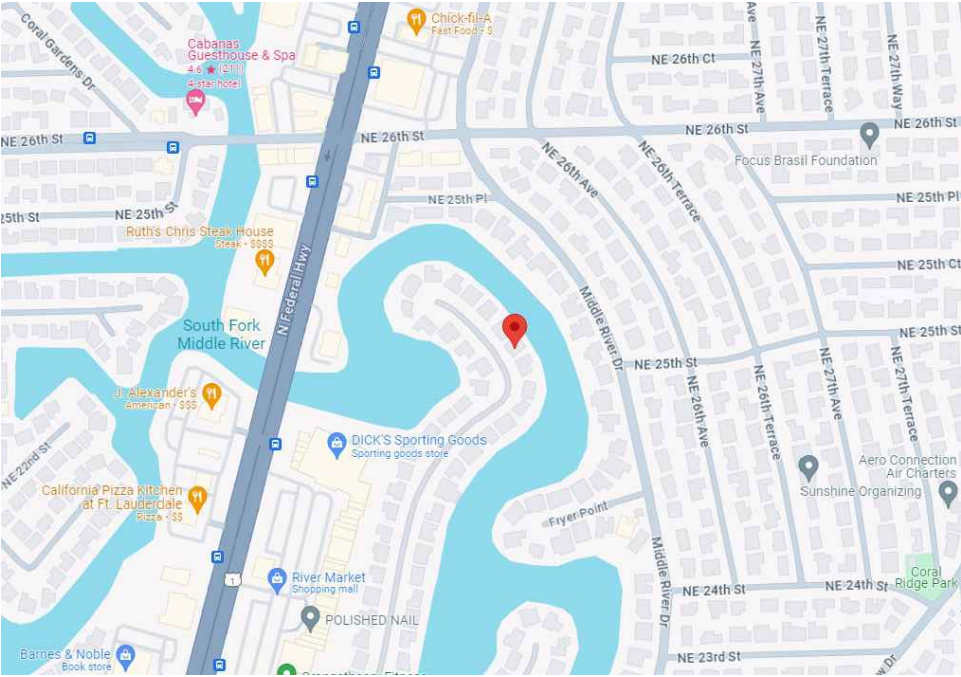

Area Map

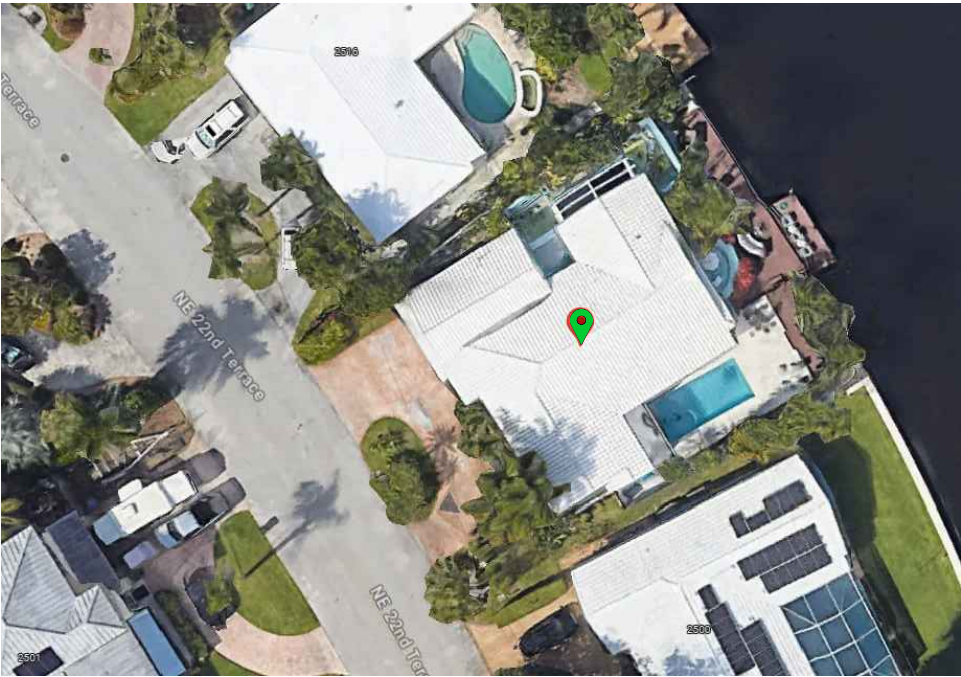

Aerial Photograph



Existing Site Photograph



360 Photo / As-Built Survey

Project Name

FCID

N/A

Address

Project Total S.F.

2,856



Arktech Solutions LLC
10804 Inside Loop
Orlando, FL 32825
P 214 606 5281
www.arktech.org



- 1 GAS MAIN & METER
- 2 WATER MAIN & METER
- 3 ELECTRIC MAIN & METER



ACCESSIBLE
PARKING STALL



ACCESSIBLE
PATH OF TRAVEL

N

SCALE: NTS

01

360 Vantage Point

01

Still Photo

01

Red Flag Notification


OWNER:

CLIENT:




Arktech Solutions LLC.
10804 Inside Loop
Orlando, FL 32825
tel: (214) 606-5281
www.Arktech.org

FC NAME:	
FCID:	
FC ADDRESS:	
FIELD SURVEYOR:	
PROJECT DIRECTOR:	
CHECKED BY:	
DATE COMPLETED:	
PROJECT NUMBER:	
SHEET:	
DRAWING NUMBER:	OF:
DRAWING NAME:	

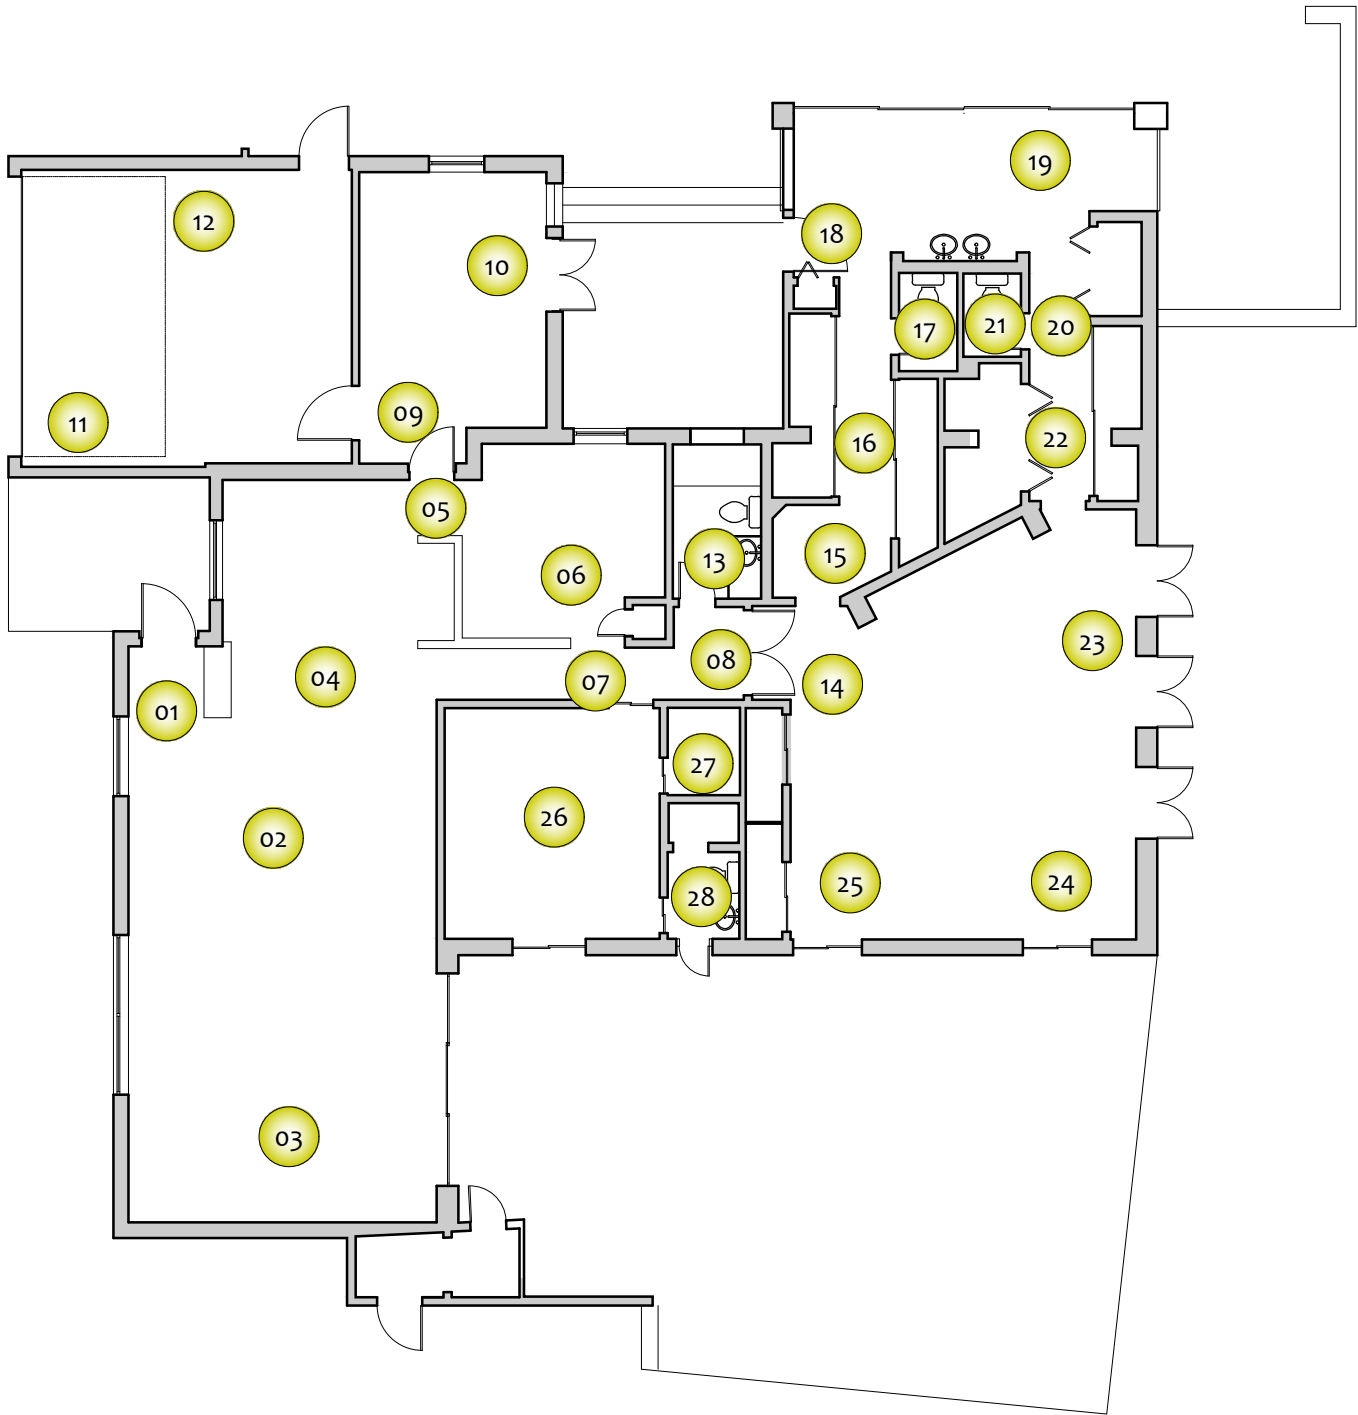

FLOOR GROSS SF: 2,856

 SCALE: 3/32" = 1'-0"

-  360 Vantage Point
-  Still Photo
-  Red Flag Notification


OWNER:

CLIENT:



Arktech Solutions LLC.
10804 Inside Loop
Orlando, FL 32825
tel: (214) 606-5281
www.Arktech.org

FC NAME:		----
FCID:		N/A
FC ADDRESS:		----- ----- -----
FIELD SURVEYOR:		----
PROJECT DIRECTOR:		----
CHECKED BY:		----
DATE COMPLETED:		3-18-2024
PROJECT NUMBER:		24903B
SHEET:		A001
DRAWING NUMBER:	OF:	039
DRAWING NAME:		

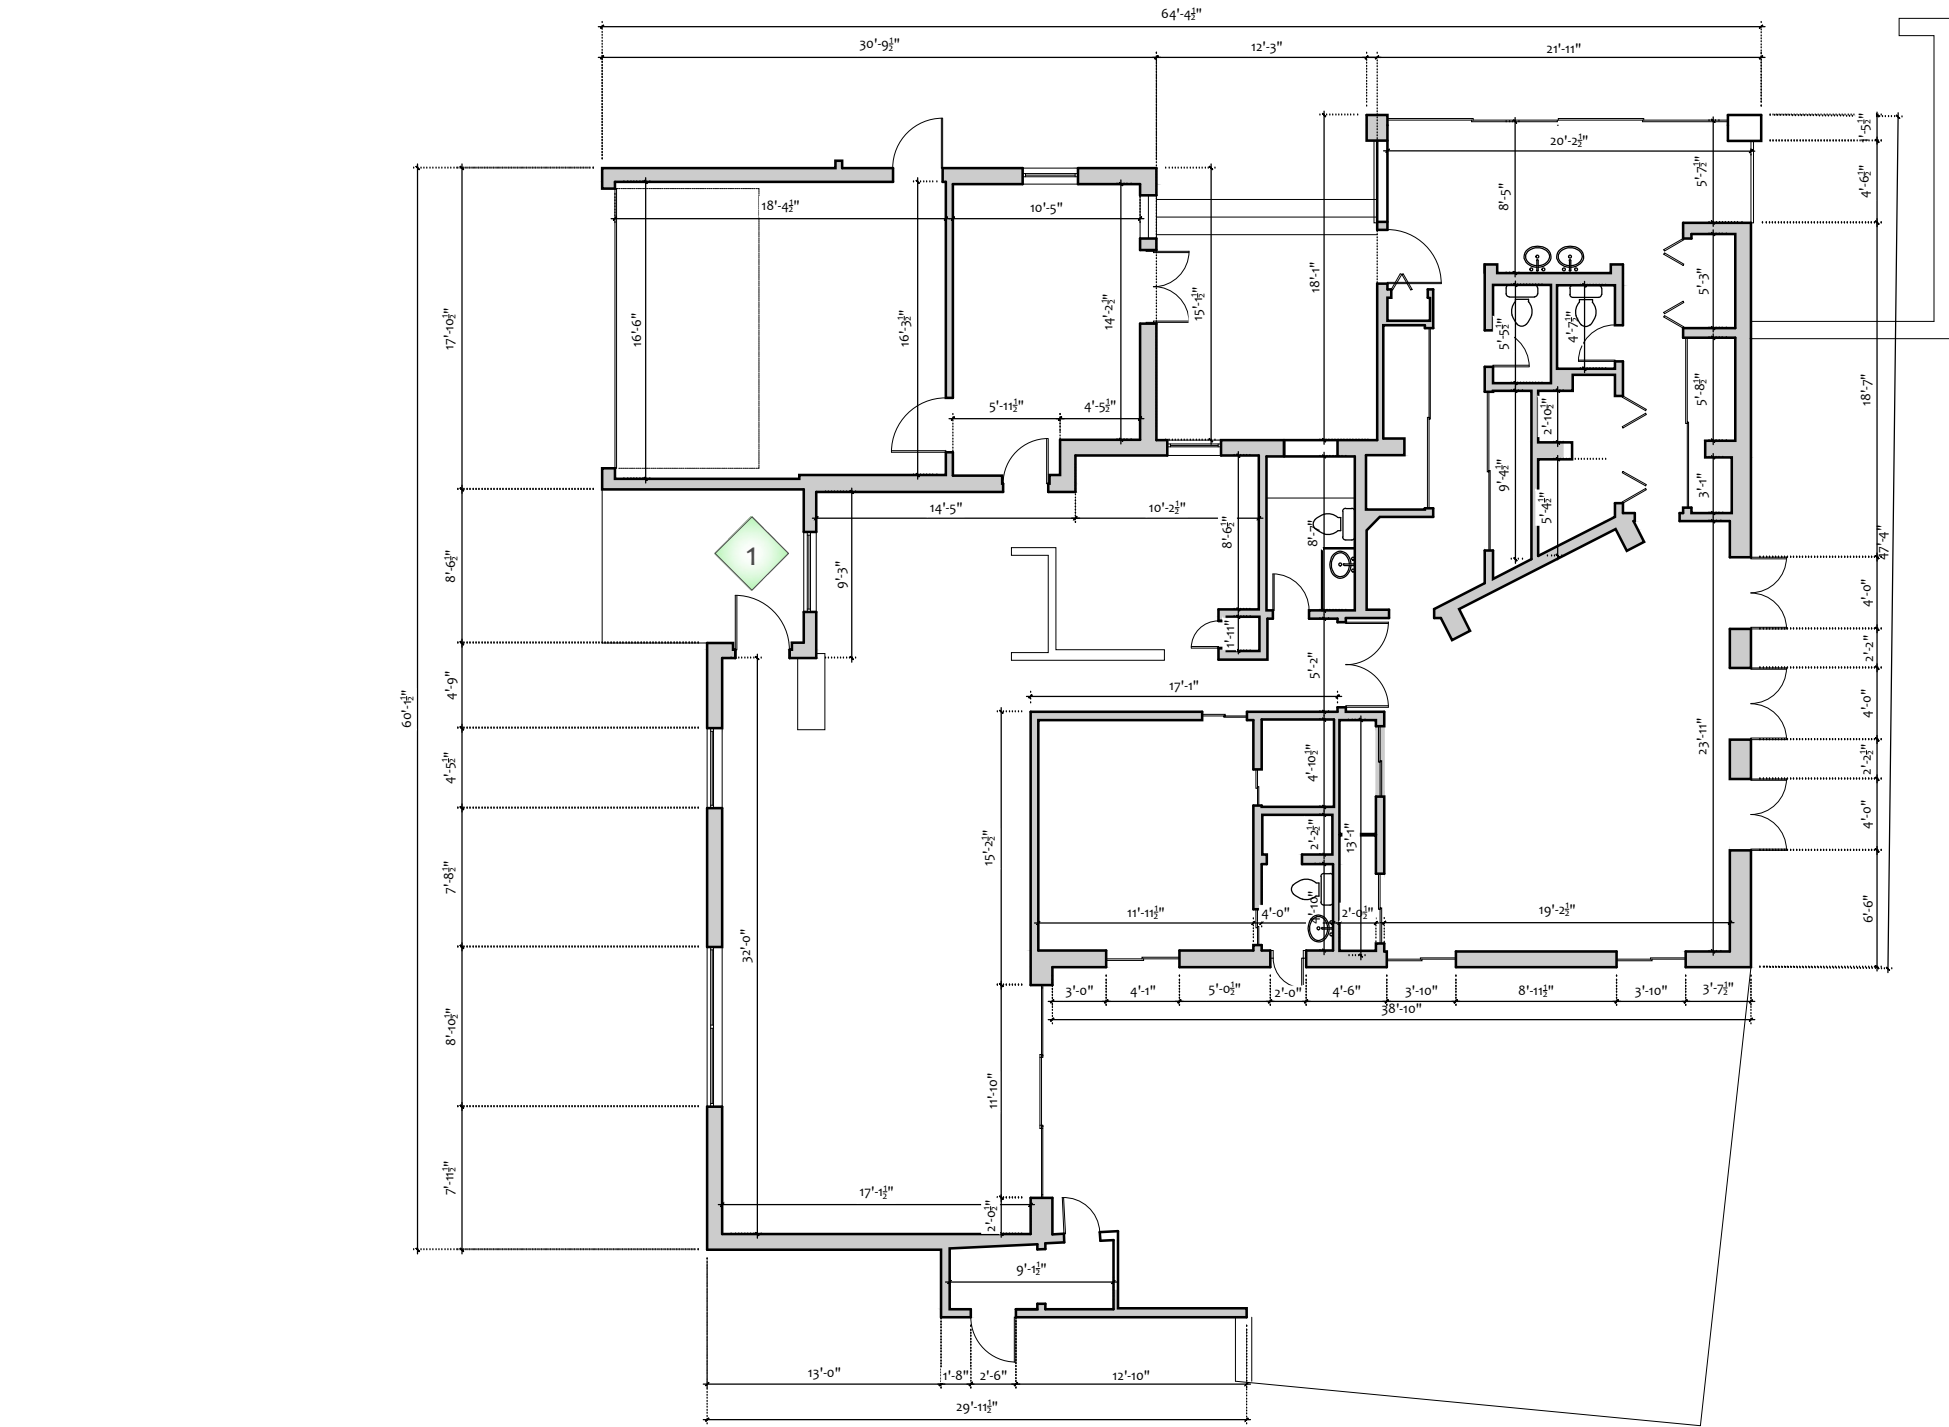

- 1

BUILDING ENTRANCE
- 2

EMERGENCY/ ALARMED EXIT DOOR

- CPT

CARPET
- TILE

TILE
- WOOD

WOOD
- S-LIN

LINOLEUM SHEET
- MAT

FLOOR MAT
- VCT

VINYL COMP. TILE
- CONC

CONCRETE

- DUPLEX OUTLET
- QUAD PLEX OUTLET
- DATA OUTLET
- DATA/ TELEPHONE
- TELEPHONE
- DUPLEX - FLOOR
- QUADPLEX - FLOOR

DATA - FLOORDATA / TELE - FLOORTHERMOSTATFIRE EXTINGUISHERFIRE HOSELIGHT SWITCH

- SEC. CONT'L. PANEL
- MONITOR
- AV OUTLET
- ELEC PANEL - RECESSED
- ELEC PANEL - SURFACE
- ELEC GENERATOR

- CARD READER
- KEYPAD LOCK
- PULL STATION
- FIRE CUT-OFF VALVE
- DRINKING FOUNTAIN

- VAULT
- VCT
- COLUMN SIZE
6.5" X 6.5"
@32'-0" O.C.

ROOM NAME & FLOORING MATERIAL



INTERIOR ELEVATIONS



EXTERIOR ELEVATIONS

FLOOR GROSS SF: 2,856

SCALE: 3/32" = 1'-0"


OWNER:

CLIENT:



Arktech Solutions LLC.
10804 Inside Loop
Orlando, FL 32825
tel: (214) 606-5281
www.Arktech.org

FC NAME: ----	
FCID: N/A	
FC ADDRESS: ----- ----- -----	
FIELD SURVEYOR: ----	
PROJECT DIRECTOR: ----	
CHECKED BY: -----	
DATE COMPLETED: 3-18-2024	
PROJECT NUMBER: 24903B	
SHEET: A002	
DRAWING NUMBER: 04	OF: 9
DRAWING NAME: 1st FLOOR PLAN	

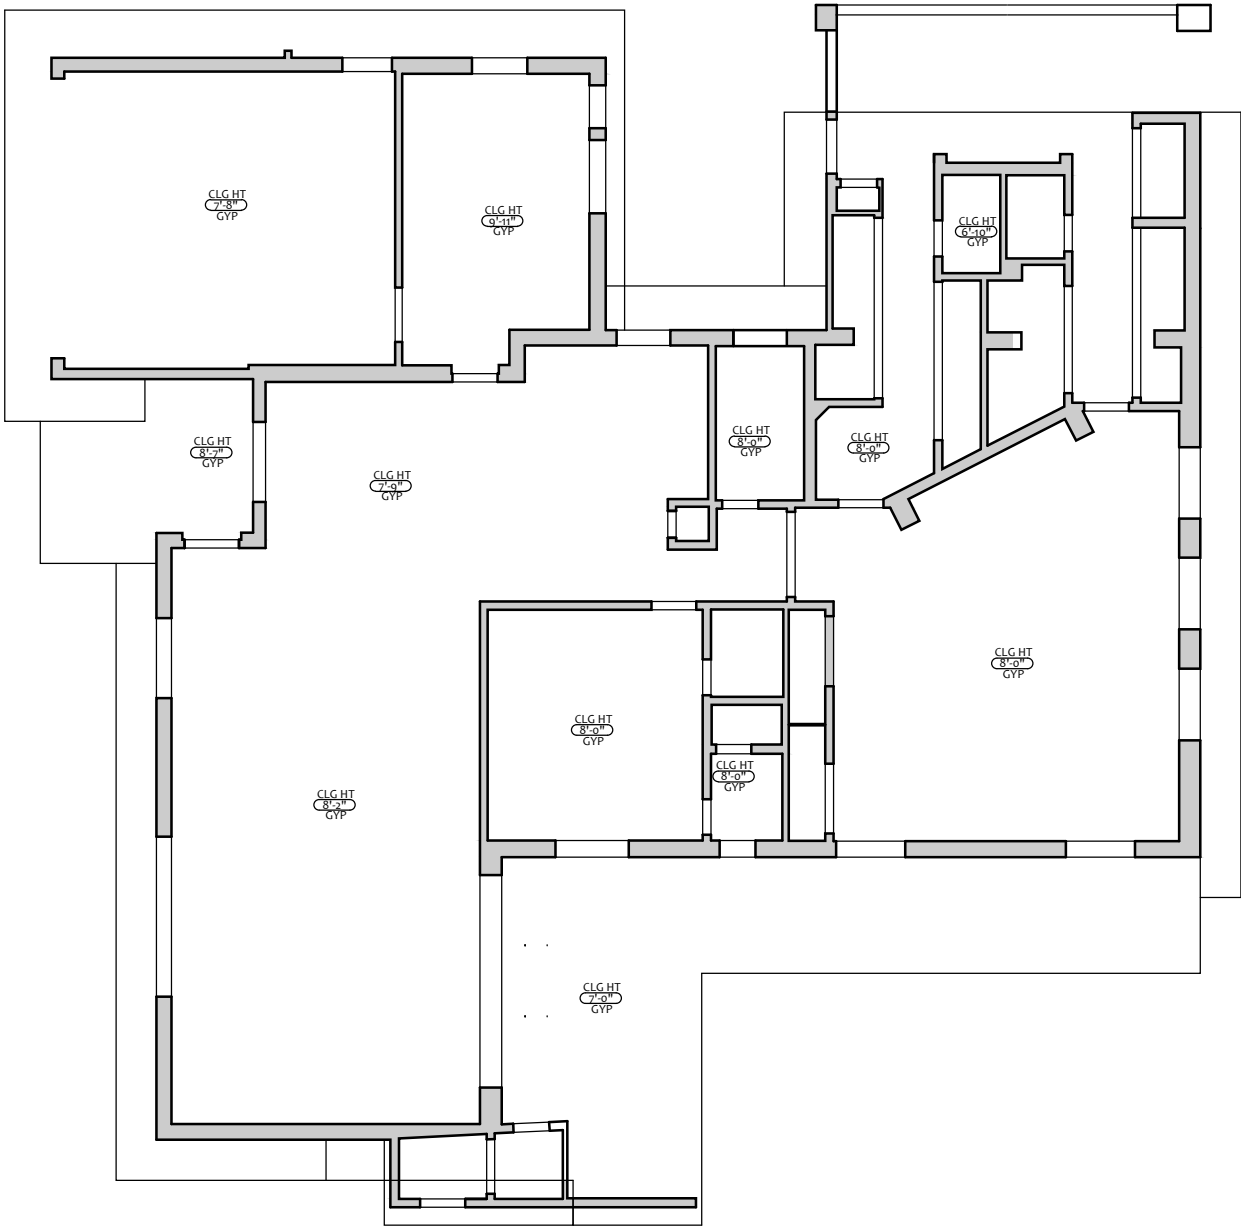

ACT
GYP BD
STRUCT
CONC
METAL
WOOD
ACT DIR
APP

CEILING TILE
GYPSUM BOARD
STRUCTURE
CONCRETE
METAL
WOOD
CEILING TILE,
DIRECT-APPLIED

- | | | |
|-----------------------|-----------------|-------------------------|
| DUPLEX - CEILING | SMOKE DETECTOR | MOTION SENSOR - CEILING |
| QUADPLEX - CEILING | FIRE SPRINKLER | MOTION SENSOR - WALL |
| DATA - CEILING | EMERGENCY LIGHT | FIRE STROBE |
| DATA / TELE - CEILING | FIRE HORN/ALARM | SURVEILLANCE CAMERA |
| SPEAKER | MONITOR | CAMERA BUBBLE |
| | EXIT SIGN | |

- | | | |
|-----------------------------|-----------------------|---------------------|
| 2 x 4 FLUORESCENT FIXTURE | RECESSED CAN LIGHT | SUPPLY AIR REGISTER |
| 2 x 2 FLUORESCENT FIXTURE | ADJUSTABLE CAN LIGHT | RETURN AIR REGISTER |
| FLUORESCENT FIXTURE | PENDANT LIGHT | SUPPLY REGISTERS |
| UTILITY FLUORESCENT FIXTURE | WALL SCONCE | VENT |
| TRACK LIGHT FIXTURE | SURFACE MOUNTED LIGHT | CEILING FAN |

FLOOR GROSS SF: 2,856

N

SCALE: 3/32" = 1'-0"

CLG HT 8'-0" ACT


HEIGHT OF CEILING
FROM FLOOR &
CEILING MATERIAL

OWNER:

CLIENT:

Arktech Solutions LLC.
10804 Inside Loop
Orlando, FL 32825
tel: (214) 606-5281
www.Arktech.org


FC NAME: ----	
FCID: N/A	
FC ADDRESS: ----- ----- -----	
FIELD SURVEYOR: ----	
PROJECT DIRECTOR: ----	
CHECKED BY: -----	
DATE COMPLETED: 3-18-2024	
PROJECT NUMBER: 24903B	
SHEET: A003	
DRAWING NUMBER: 05	OF: 9
DRAWING NAME: REF. CLNG 1st FL PLAN	

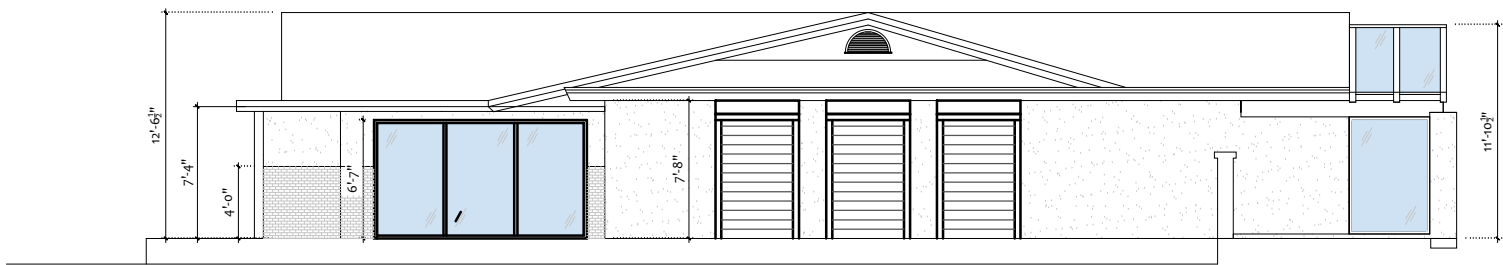

NORTH EAST EXTERIOR ELEVATION

SCALE:
3/32"=1'-0"

1

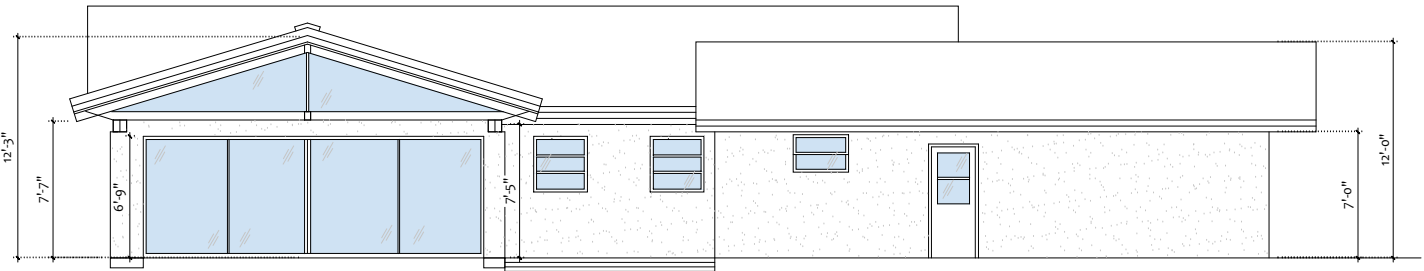

NORTH WEST EXTERIOR ELEVATION

SCALE:
3/32"=1'-0"

2

OWNER:

CLIENT:




Arktech Solutions LLC.
10804 Inside Loop
Orlando, FL 32825
tel: (214) 606-5281
www.Arktech.org

FC NAME:	----
FCID:	N/A
FC ADDRESS:	----- ----- -----

FIELD SURVEYOR:	----
PROJECT DIRECTOR:	----
CHECKED BY:	----
DATE COMPLETED:	3-18-2024

PROJECT NUMBER:	24903B
SHEET:	AX001
DRAWING NUMBER:	08
OF:	9

DRAWING NAME:	EXTERIOR ELEVATIONS
---------------	---------------------

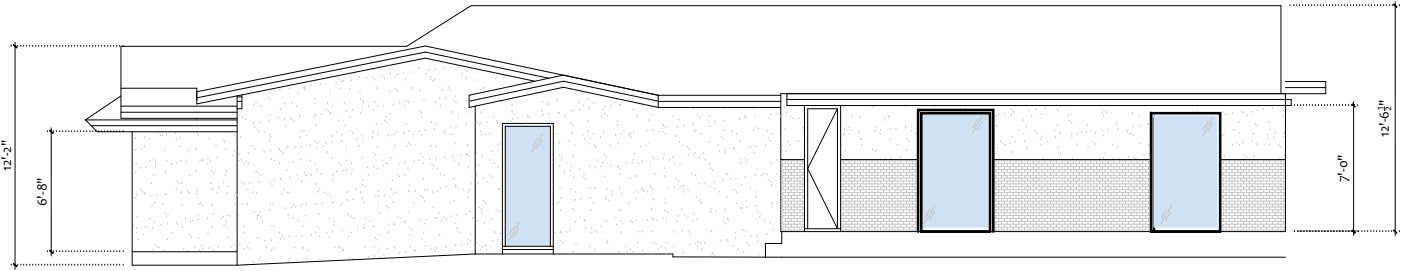

SOUTH EAST EXTERIOR ELEVATION

SCALE:
3/32"=1'-0"

3



SOUTH WEST EXTERIOR ELEVATION

SCALE:
3/32"=1'-0"

4

OWNER:

CLIENT:



Arktech Solutions LLC.
10804 Inside Loop
Orlando, FL 32825
tel: (214) 606-5281
www.Arktech.org

FC NAME:	----
FCID:	N/A
FC ADDRESS:	----- ----- -----

FIELD SURVEYOR:	----
PROJECT DIRECTOR:	----
CHECKED BY:	----
DATE COMPLETED:	3-18-2024

PROJECT NUMBER:	
24903B	
SHEET:	
AX002	
DRAWING NUMBER:	OF:
09	9

DRAWING NAME:
EXTERIOR ELEVATIONS