


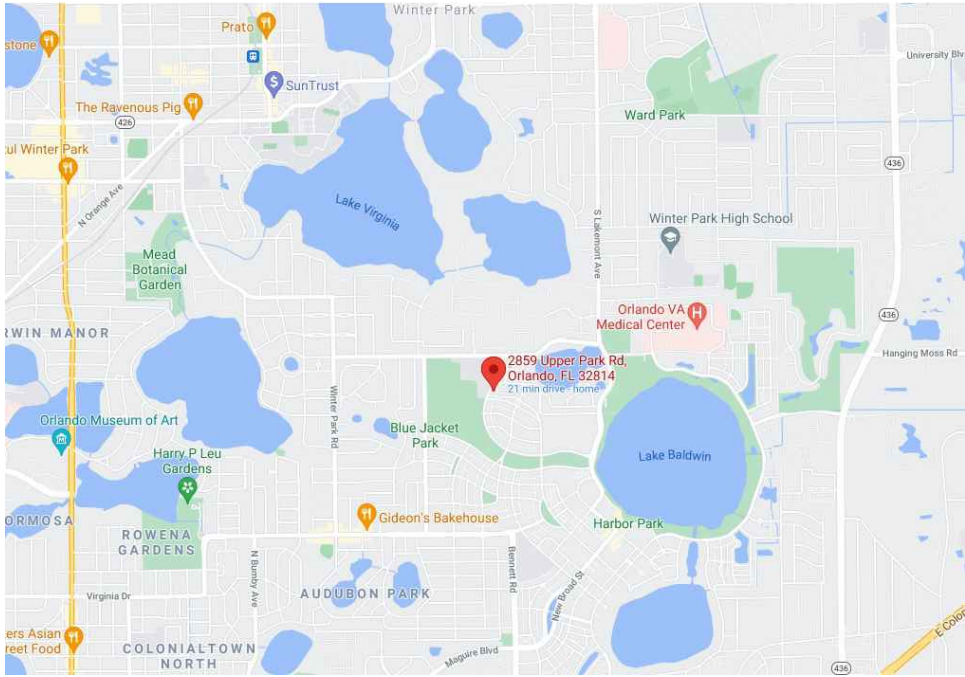

Area Map



Aerial Photograph



Existing Site Photograph



360 Photo / As-Built Survey

Project Name

FCID

N/A

Address

Project Total S.F.

1,888



Arktech Solutions LLC
10804 Inside Loop
Orlando, FL 32825
P 214 606 5281
www.arktech.org



- 1 GAS MAIN & METER
- 2 WATER MAIN & METER
- 3 ELECTRIC MAIN & METER



ACCESSIBLE
PARKING STALL



ACCESSIBLE
PATH OF TRAVEL



SCALE: NTS

01 360 Vantage
Point

01 Still Photo

01 Red Flag
Notification

OWNER:

CLIENT:



Arktech Solutions LLC.
10804 Inside Loop
Orlando, FL 32825
tel: (214) 606-5281
www.Arktech.org

FC NAME:	

FCID:	
N/A	
FC ADDRESS:	


FIELD SURVEYOR:	

PROJECT DIRECTOR:	

CHECKED BY:	

DATE COMPLETED:	
05-10-2021	
PROJECT NUMBER:	

SHEET:	
SP01	
DRAWING NUMBER:	OF:
02	10
DRAWING NAME:	
SITE PLAN	

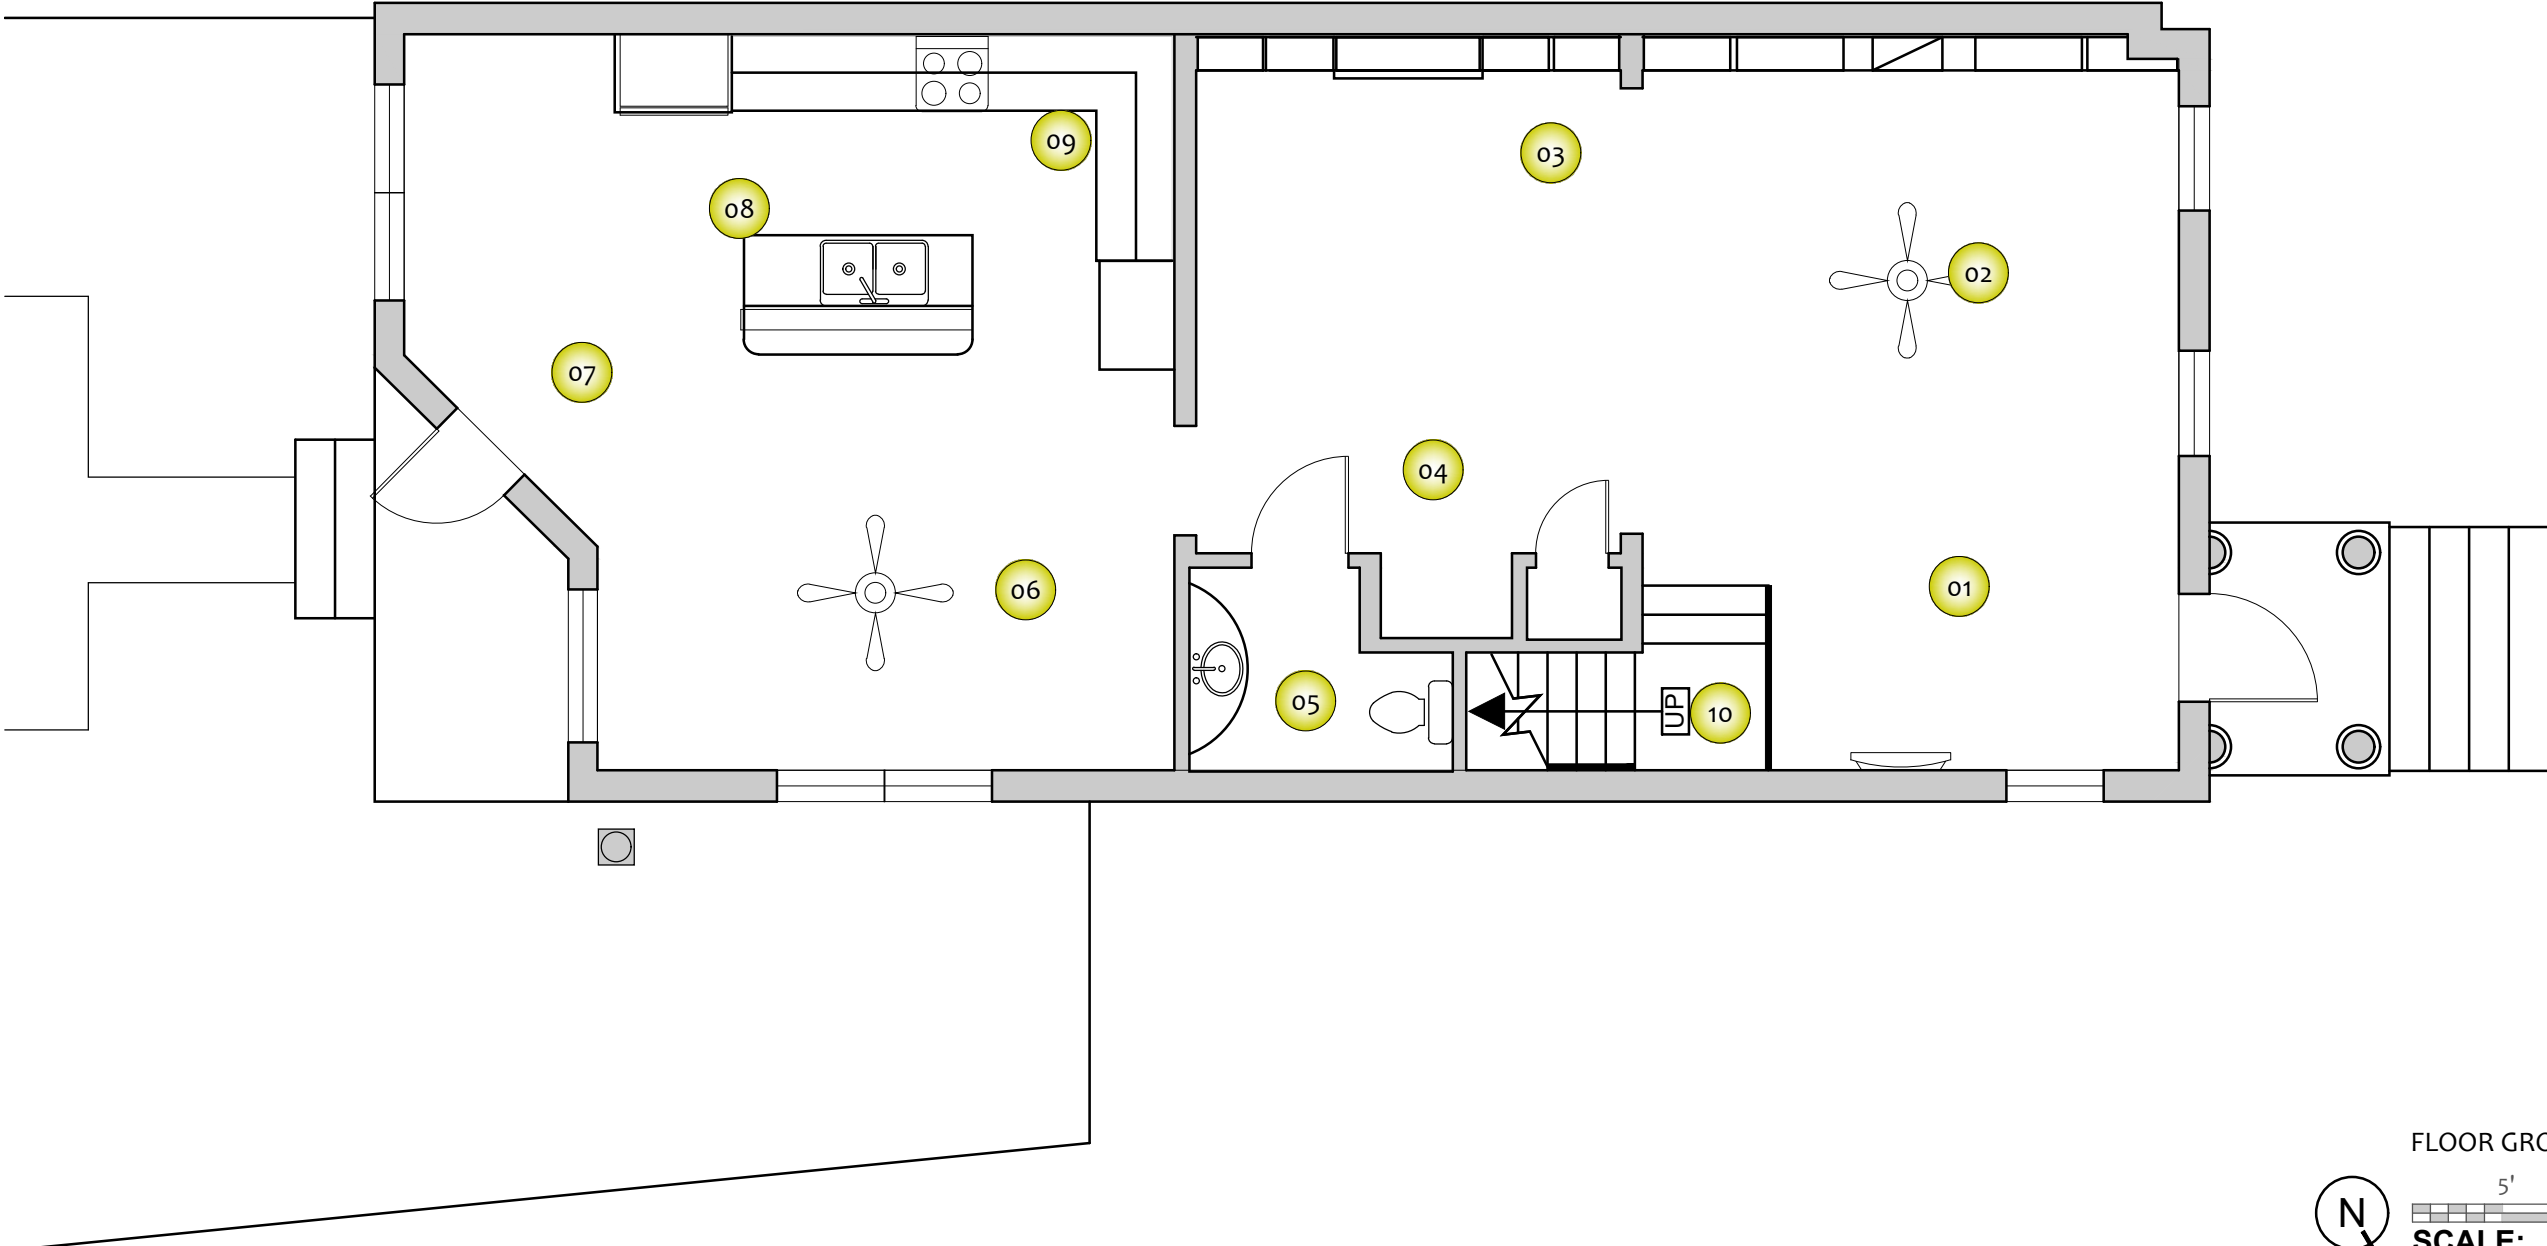

FLOOR GROSS SF: 959

SCALE: 3/32" = 1'-0"

- 01 360 Vantage Point
- 01 Still Photo
- 01 Red Flag Notification

OWNER:

CLIENT:



Arktech Solutions LLC.
10804 Inside Loop
Orlando, FL 32825
tel: (214) 606-5281
www.Arktech.org

FC NAME:	

FCID:	
N/A	
FC ADDRESS:	


FIELD SURVEYOR:	

PROJECT DIRECTOR:	

CHECKED BY:	

DATE COMPLETED:	
05-10-2021	
PROJECT NUMBER:	

SHEET:	
A001	
DRAWING NUMBER:	OF:
03	10
DRAWING NAME:	
360 PHOTO PLAN 1ST FL.	

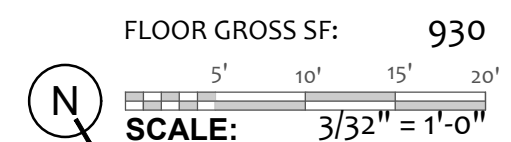

- | | | | | | |
|--|-------------------------|------------------------|------------|-----------|-----------|
| <p>OWNER:</p>

<hr/> <p>CLIENT:</p>

<hr/> <div style="text-align: center;">  <p>Arktech Solutions LLC.
 10804 Inside Loop
 Orlando, FL 32825
 tel: (214) 606-5281
 www.Arktech.org</p> </div> | | | | | |
| FC NAME: | ---- | | | | |
| FCID: | N/A | | | | |
| FC ADDRESS: | -----

----- | | | | |
| <p>FIELD SURVEYOR:</p> <p style="text-align: center;">-----</p> <p>PROJECT DIRECTOR:</p> <p style="text-align: center;">-----</p> <p>CHECKED BY:</p> <p style="text-align: center;">-----</p> <p>DATE COMPLETED:</p> <p style="text-align: center;">05-10-2021</p> | | | | | |
| <p>PROJECT NUMBER:</p> <p style="text-align: center;">-----</p> <p>SHEET:</p> <p style="text-align: center;">A001.1</p> <table border="1" style="width: 100%; border-collapse: collapse;"> <tr> <td style="width: 50%;">DRAWING NUMBER:</td> <td style="width: 50%;">OF:</td> </tr> <tr> <td style="text-align: center;">04</td> <td style="text-align: center;">10</td> </tr> </table> | | DRAWING NUMBER: | OF: | 04 | 10 |
| DRAWING NUMBER: | OF: | | | | |
| 04 | 10 | | | | |
| <p>DRAWING NAME:</p> <p>360 PHOTO PLAN 2nd FL</p> | | | | | |



FLOOR GROSS SF:
5' 10' 15' 20'
SCALE: 3/32" = 1'-0"

01 360 Vantage Point

01 Still Photo

01 Red Flag Notification

OWNER:

CLIENT:




Arktech Solutions LLC.
10804 Inside Loop
Orlando, FL 32825
tel: (214) 606-5281
www.Arktech.org

FC NAME:	----
FCID:	N/A
FC ADDRESS:	----- ----- -----

FIELD SURVEYOR:	----
PROJECT DIRECTOR:	----
CHECKED BY:	----
DATE COMPLETED:	05-10-2021

PROJECT NUMBER:	----
SHEET:	A001.2
DRAWING NUMBER:	05
OF:	10

DRAWING NAME:	360 PHOTO PLAN PATIO
---------------	----------------------

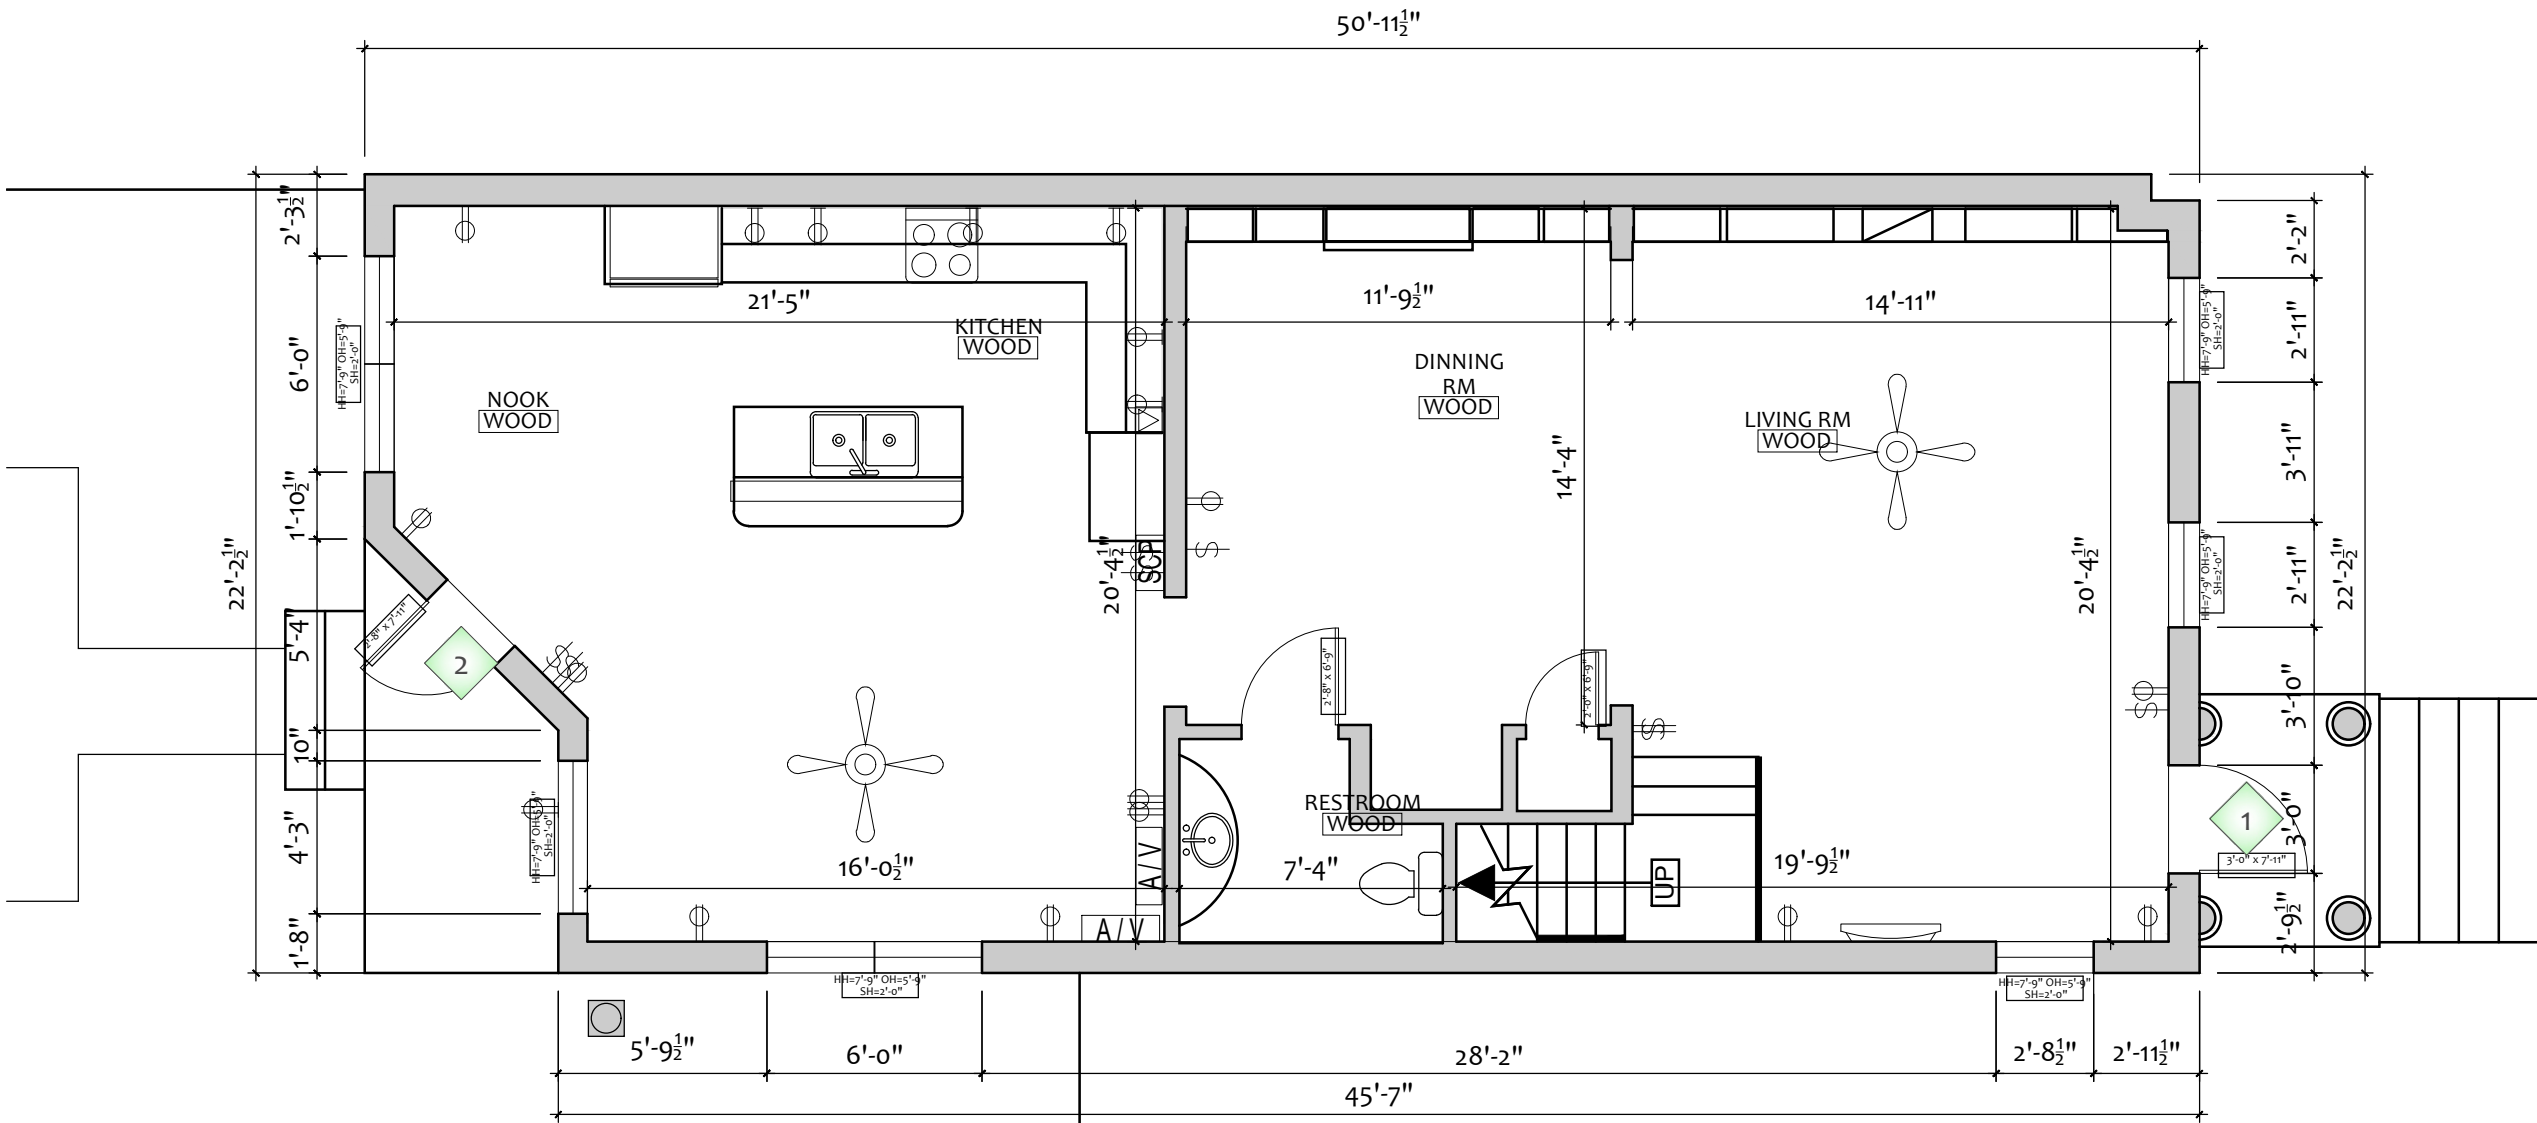

- 1 BUILDING ENTRANCE
- 2 EMERGENCY/ ALARMED EXIT DOOR

- CPT CARPET
- TILE TILE
- WOOD WOOD
- S-LIN LINOLEUM SHEET
- MAT FLOOR MAT
- VCT VINYL COMP. TILE
- CONC CONCRETE

- ⌀ DUPLEX OUTLET
- ⊕ QUAD PLEX OUTLET
- ▼ DATA OUTLET
- ▼ DATA/ TELEPHONE
- ⊘ TELEPHONE
- ⊞ DUPLEX - FLOOR
- ⊞ QUADPLEX - FLOOR
- ▼ DATA - FLOOR
- ▼ DATA / TELE - FLOOR
- Ⓣ THERMOSTAT
- Ⓕ FIRE EXTINGUISHER
- Ⓕ FIRE HOSE
- Ⓕ LIGHT SWITCH

- SCP SEC. CONT'L. PANEL
- MONITOR
- AV AV OUTLET
- ELEC PANEL - RECESSED
- ELEC PANEL - SURFACE
- GENERATOR ELEC GENERATOR

- C CARD READER
- K KEYPAD LOCK
- P PULL STATION
- V FIRE CUT-OFF VALVE
- DRINKING FOUNTAIN

VAULT
VCT

COLUMN SIZE
6.5" X 6.5"
@32'-0" O.C.

ROOM NAME &
FLOORING MATERIAL

COLUMN SIZE &
FREQUENCY



INTERIOR
ELEVATIONS



EXTERIOR
ELEVATIONS

FLOOR GROSS SF: 959

SCALE: 3/32" = 1'-0"

OWNER:

CLIENT:




Arktech Solutions LLC.
10804 Inside Loop
Orlando, FL 32825
tel: (214) 606-5281
www.Arktech.org

FC NAME:	----
FCID:	N/A
FC ADDRESS:	----- ----- -----

FIELD SURVEYOR:	----
PROJECT DIRECTOR:	----
CHECKED BY:	----
DATE COMPLETED:	05-10-2021

PROJECT NUMBER:	----
SHEET:	A002
DRAWING NUMBER:	06
OF:	10

DRAWING NAME:	1st FLOOR PLAN
---------------	----------------

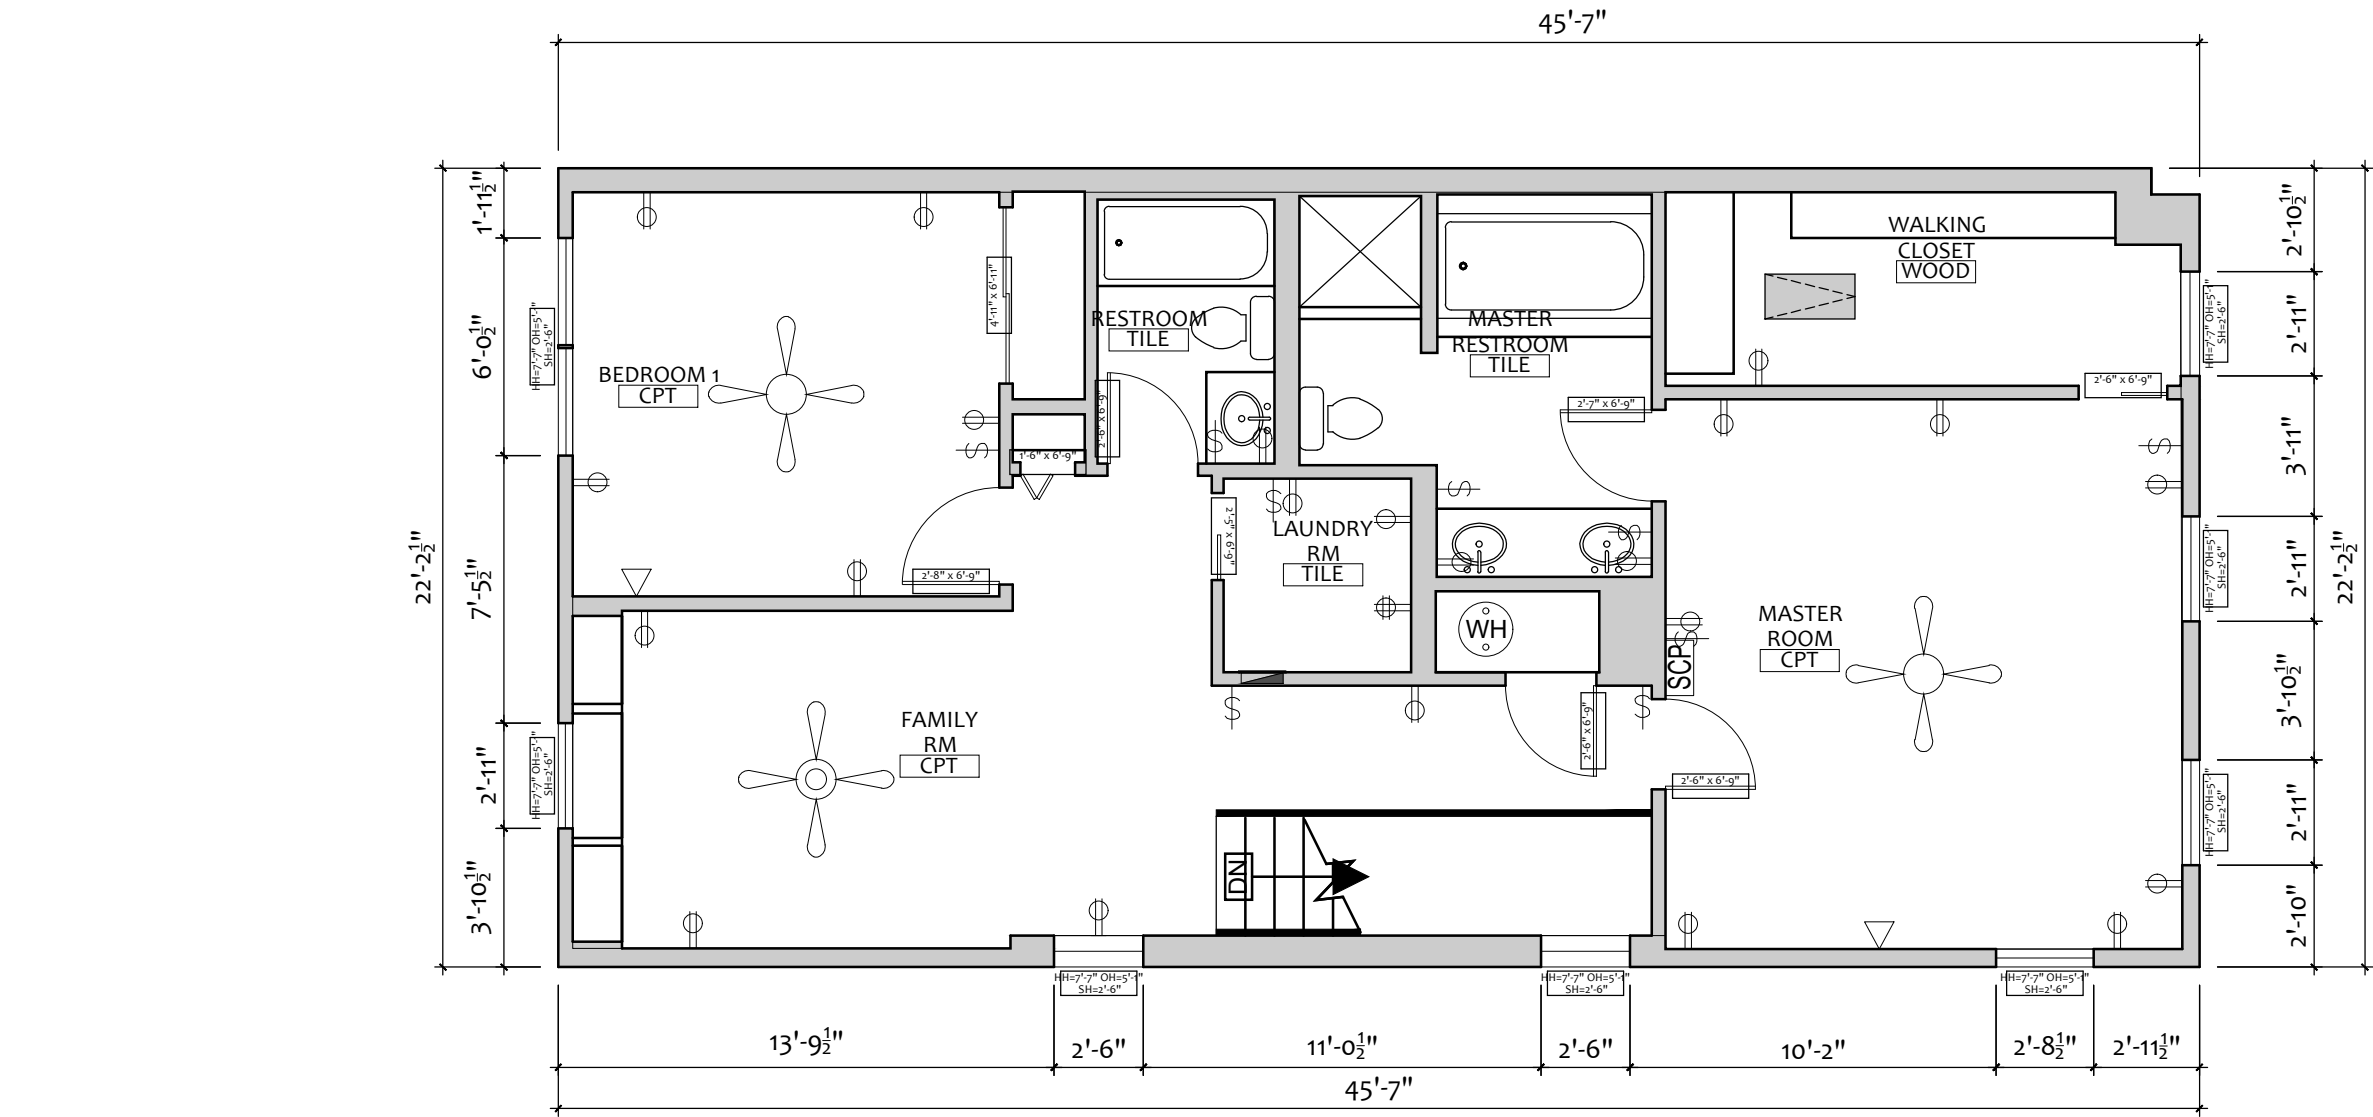

FLOOR GROSS SF: 930
SCALE: 3/32" = 1'-0"

- 1 BUILDING ENTRANCE
- 2 EMERGENCY/ ALARMED EXIT DOOR

- CPT CARPET
- TILE TILE
- WOOD WOOD
- S-LIN LINOLEUM SHEET
- MAT FLOOR MAT
- VCT VINYL COMP. TILE
- CONC CONCRETE

- ⌀ DUPLEX OUTLET
- ⌀ QUAD PLEX OUTLET
- ▼ DATA OUTLET
- ▼ DATA/ TELEPHONE
- ⌞ TELEPHONE
- ⌞ DUPLEX - FLOOR
- ⌞ QUADPLEX - FLOOR
- ▼ DATA - FLOOR
- ▼ DATA / TELE - FLOOR
- Ⓣ THERMOSTAT
- Ⓕ FIRE EXTINGUISHER
- Ⓕ FIRE HOSE
- Ⓕ LIGHT SWITCH

- SCP SEC. CONT'L. PANEL
- MONITOR
- AV AV OUTLET
- ELEC PANEL - RECESSED
- ELEC PANEL - SURFACE
- GENERATOR ELEC GENERATOR

- C CARD READER
- K KEYPAD LOCK
- P PULL STATION
- Ⓜ FIRE CUT-OFF VALVE
- Ⓜ DRINKING FOUNTAIN

VAULT VCT
COLUMN SIZE 6.5" X 6.5" @ 32'-0" O.C.

ROOM NAME & FLOORING MATERIAL



INTERIOR ELEVATIONS



EXTERIOR ELEVATIONS

OWNER:

CLIENT:




Arktech Solutions LLC.
10804 Inside Loop
Orlando, FL 32825
tel: (214) 606-5281
www.Arktech.org

FC NAME:	----
FCID:	N/A
FC ADDRESS:	----- ----- -----

FIELD SURVEYOR:	----
PROJECT DIRECTOR:	----
CHECKED BY:	----
DATE COMPLETED:	05-10-2021

PROJECT NUMBER:	----
SHEET:	A002.1
DRAWING NUMBER:	07
OF:	10

DRAWING NAME: 2nd FLOOR PLAN

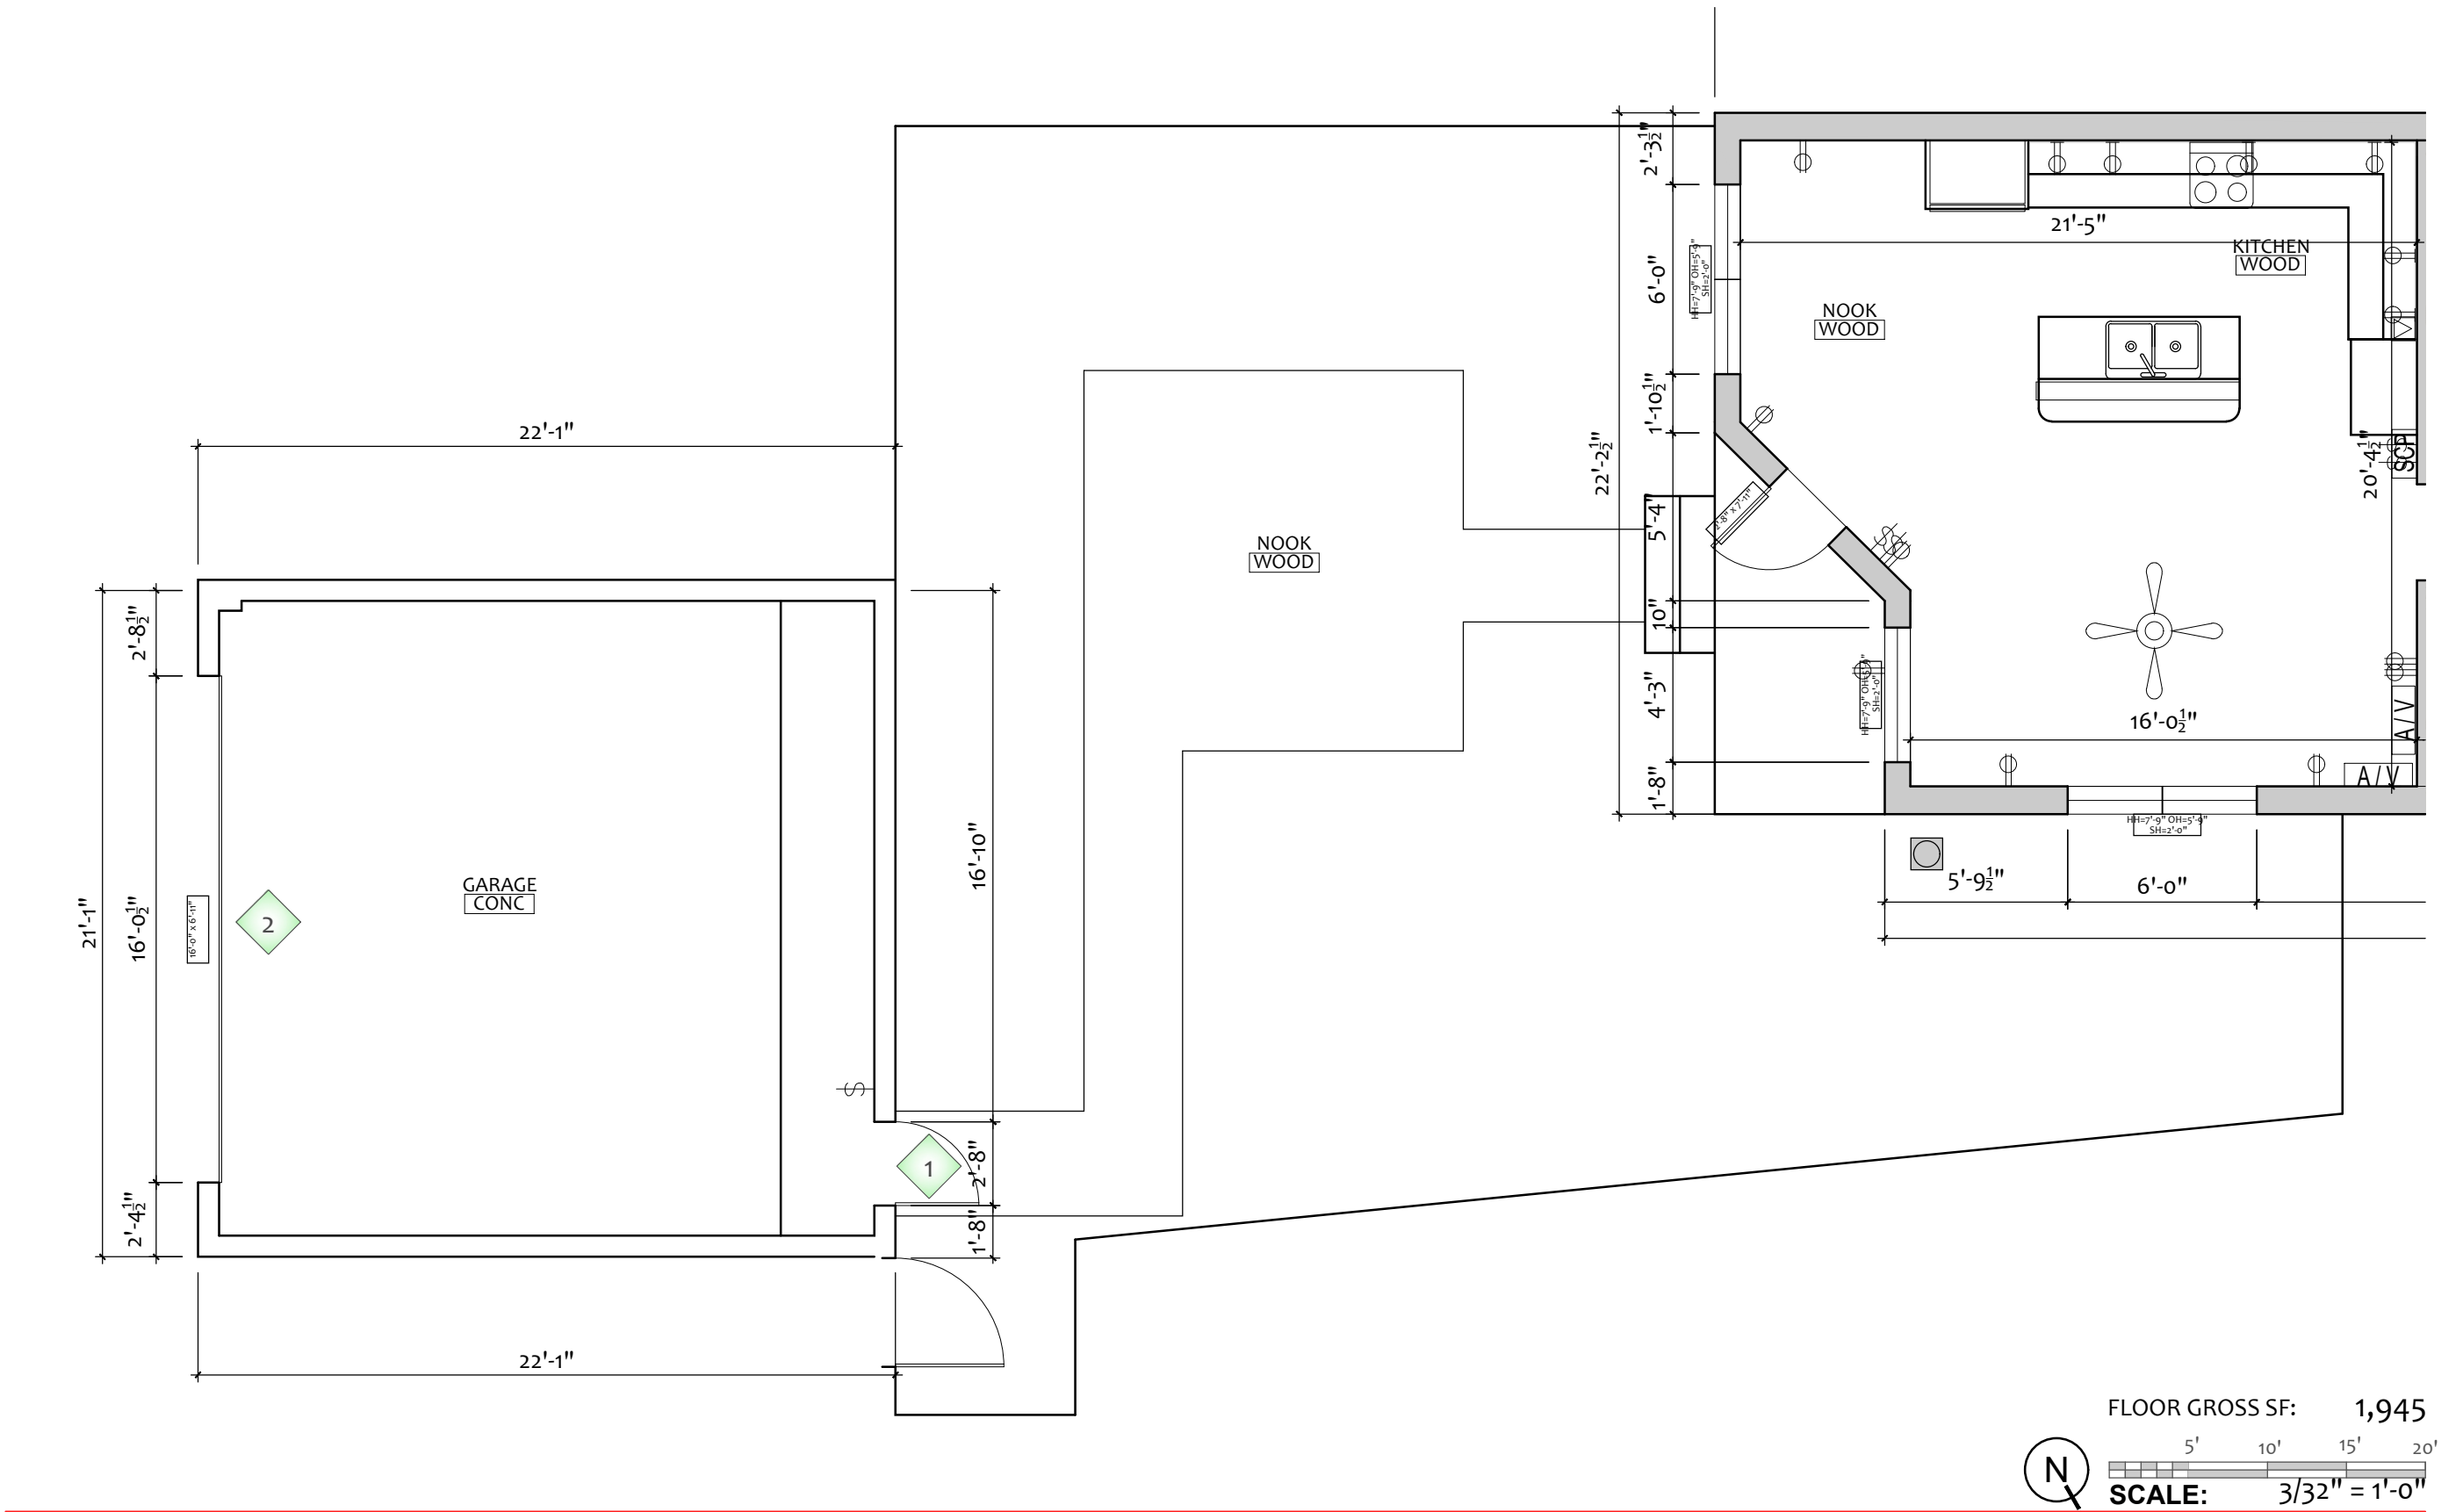

- 1 BUILDING ENTRANCE
- 2 GARAGE DOOR

- CPT CARPET
- TILE TILE
- WOOD WOOD
- S-LIN LINOLEUM SHEET
- MAT FLOOR MAT
- VCT VINYL COMP. TILE
- CONC CONCRETE

- ⌀ DUPLEX OUTLET
- ⌀ QUAD PLEX OUTLET
- ▼ DATA OUTLET
- ▼ DATA/ TELEPHONE
- ⌀ TELEPHONE
- ⌀ DUPLEX - FLOOR
- ⌀ QUADPLEX - FLOOR
- ▼ DATA - FLOOR
- ▼ DATA / TELE - FLOOR
- Ⓣ THERMOSTAT
- Ⓢ FIRE EXTINGUISHER
- Ⓢ FIRE HOSE
- Ⓢ LIGHT SWITCH

- SCP SEC. CONT'L. PANEL
- MONITOR
- AV AV OUTLET
- ELEC PANEL - RECESSED
- ELEC PANEL - SURFACE
- GENERATOR ELEC GENERATOR

- C CARD READER
- K KEYPAD LOCK
- P PULL STATION
- V FIRE CUT-OFF VALVE
- DRINKING FOUNTAIN

VAULT
VCT
COLUMN SIZE
6.5" X 6.5"
@ 32'-0" O.C.

ROOM NAME &
FLOORING MATERIAL



INTERIOR
ELEVATIONS



EXTERIOR
ELEVATIONS

FLOOR GROSS SF: 1,945
SCALE: 3/32" = 1'-0"

OWNER:

CLIENT:


Arktech Solutions LLC.
10804 Inside Loop
Orlando, FL 32825
tel: (214) 606-5281
www.Arktech.org

FC NAME: ----

FCID: N/A

FC ADDRESS: ----

FIELD SURVEYOR: ----

PROJECT DIRECTOR: ----

CHECKED BY: ----


DATE COMPLETED: 05-10-2021

PROJECT NUMBER: ----

SHEET: A002.2

DRAWING NUMBER: 08 OF: 10

DRAWING NAME: GARAGE FLOOR PLAN

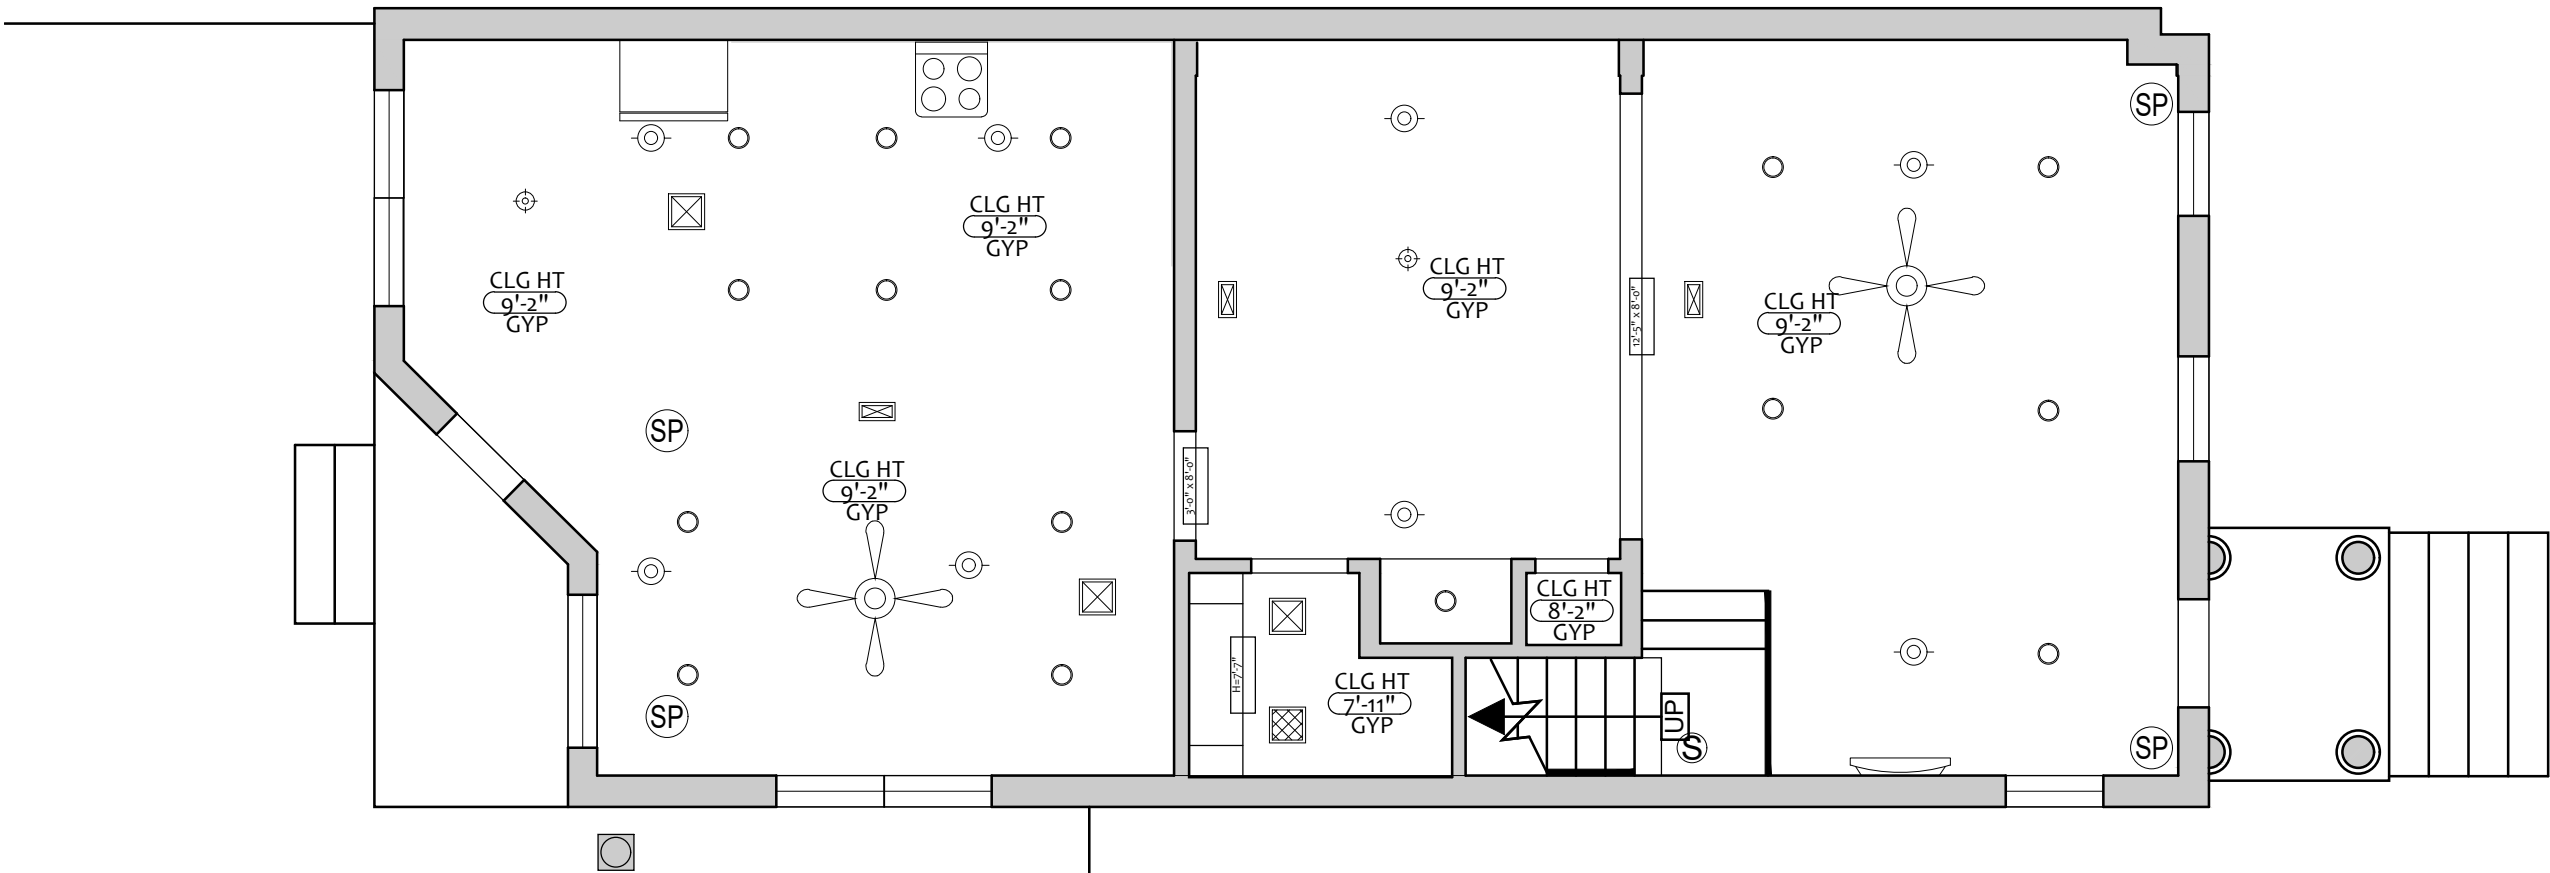

FLOOR GROSS SF: 959

SCALE: 3/32" = 1'-0"

- | | | | | | | | |
|---------|------------------------------|--|-----------------------|--|-----------------|--|-------------------------|
| ACT | CEILING TILE | | DUPLEX - CEILING | | SMOKE DETECTOR | | MOTION SENSOR - CEILING |
| GYP BD | GYPSUM BOARD | | QUADPLEX - CEILING | | FIRE SPRINKLER | | MOTION SENSOR - WALL |
| STRUCT | STRUCTURE | | DATA - CEILING | | EMERGENCY LIGHT | | FIRE STROBE |
| CONC | CONCRETE | | DATA / TELE - CEILING | | FIRE HORN/ALARM | | SURVEILLANCE CAMERA |
| METAL | METAL | | SPEAKER | | MONITOR | | CAMERA BUBBLE |
| WOOD | WOOD | | | | EXIT SIGN | | |
| ACT DIR | CEILING TILE, DIRECT-APPLIED | | | | | | |
| APP | | | | | | | |

- | | | | | | |
|--|-----------------------------|--|-----------------------|--|---------------------|
| | 2 x 4 FLUORESCENT FIXTURE | | RECESSED CAN LIGHT | | SUPPLY AIR REGISTER |
| | 2 x 2 FLUORESCENT FIXTURE | | ADJUSTABLE CAN LIGHT | | RETURN AIR REGISTER |
| | FLUORESCENT FIXTURE | | PENDANT LIGHT | | SUPPLY REGISTERS |
| | UTILITY FLUORESCENT FIXTURE | | WALL SCONCE | | VENT |
| | TRACK LIGHT FIXTURE | | SURFACE MOUNTED LIGHT | | CEILING FAN |

CLG HT 8'-0" ACT
HEIGHT OF CEILING FROM FLOOR & CEILING MATERIAL

OWNER:

CLIENT:




Arktech Solutions LLC.
10804 Inside Loop
Orlando, FL 32825
tel: (214) 606-5281
www.Arktech.org

FC NAME:	----
FCID:	N/A
FC ADDRESS:	----- ----- -----


FIELD SURVEYOR:	----
PROJECT DIRECTOR:	----
CHECKED BY:	----
DATE COMPLETED:	05-10-2021

PROJECT NUMBER:	----
SHEET:	A003
DRAWING NUMBER:	09
OF:	10

DRAWING NAME:	REF. CLNG 1st FL PLAN
---------------	-----------------------

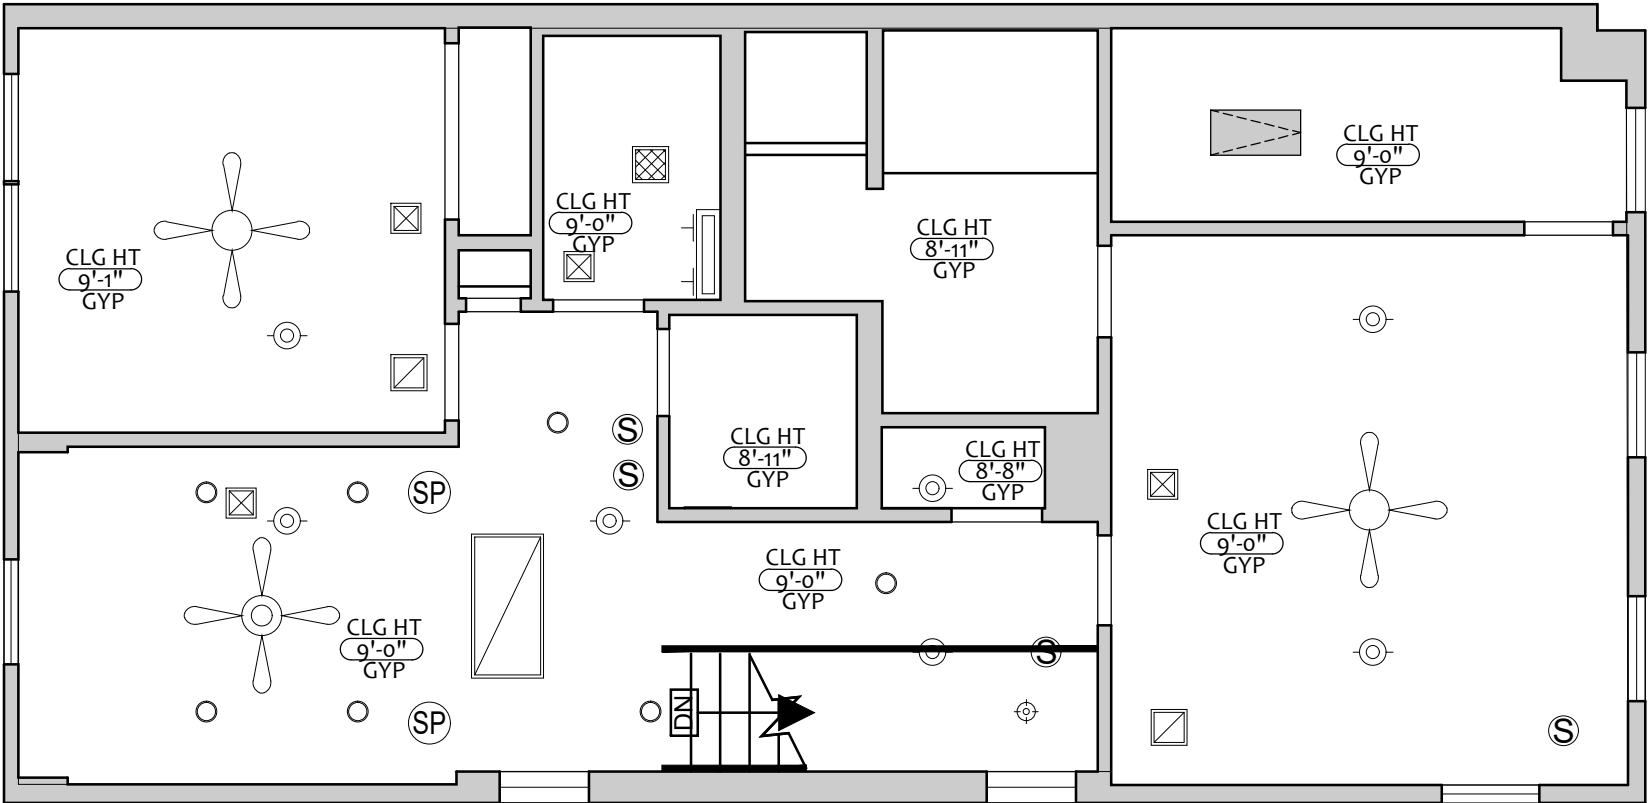

FLOOR GROSS SF: 930

 

ACT
GYP BD
STRUCT
CONC
METAL
WOOD
ACT DIR
APP

CEILING TILE
GYPSUM BOARD
STRUCTURE
CONCRETE
METAL
WOOD
CEILING TILE,
DIRECT-APPLIED

DUPLEX - CEILING
 QUADPLEX - CEILING
 DATA - CEILING
 DATA / TELE - CEILING
 SPEAKER

SMOKE DETECTOR
 FIRE SPRINKLER
 EMERGENCY LIGHT
 FIRE HORN/ALARM
 MONITOR
 EXIT SIGN

MOTION SENSOR - CEILING
 MOTION SENSOR - WALL
 FIRE STROBE
 SURVEILLANCE CAMERA
 CAMERA BUBBLE

2 x 4 FLUORESCENT FIXTURE
 2 x 2 FLUORESCENT FIXTURE
 FLUORESCENT FIXTURE
 UTILITY FLUORESCENT FIXTURE
 TRACK LIGHT FIXTURE

RECESSED CAN LIGHT
 ADJUSTABLE CAN LIGHT
 PENDANT LIGHT
 WALL SCONCE
 SURFACE MOUNTED LIGHT

SUPPLY AIR REGISTER
 RETURN AIR REGISTER
 SUPPLY REGISTERS
 VENT
 CEILING FAN

CLG HT 8'-0" ACT
HEIGHT OF CEILING
FROM FLOOR &
CEILING MATERIAL

OWNER:

CLIENT:



Arktech Solutions LLC.
10804 Inside Loop
Orlando, FL 32825
tel: (214) 606-5281
www.Arktech.org

FC NAME:	----
FCID:	N/A
FC ADDRESS:	----- ----- -----

FIELD SURVEYOR:	----
PROJECT DIRECTOR:	----
CHECKED BY:	----
DATE COMPLETED:	05-10-2021

PROJECT NUMBER:	----
SHEET:	A003.1
DRAWING NUMBER:	10
OF:	10

DRAWING NAME:	REF. CLNG 2nd FL PLAN
---------------	-----------------------